
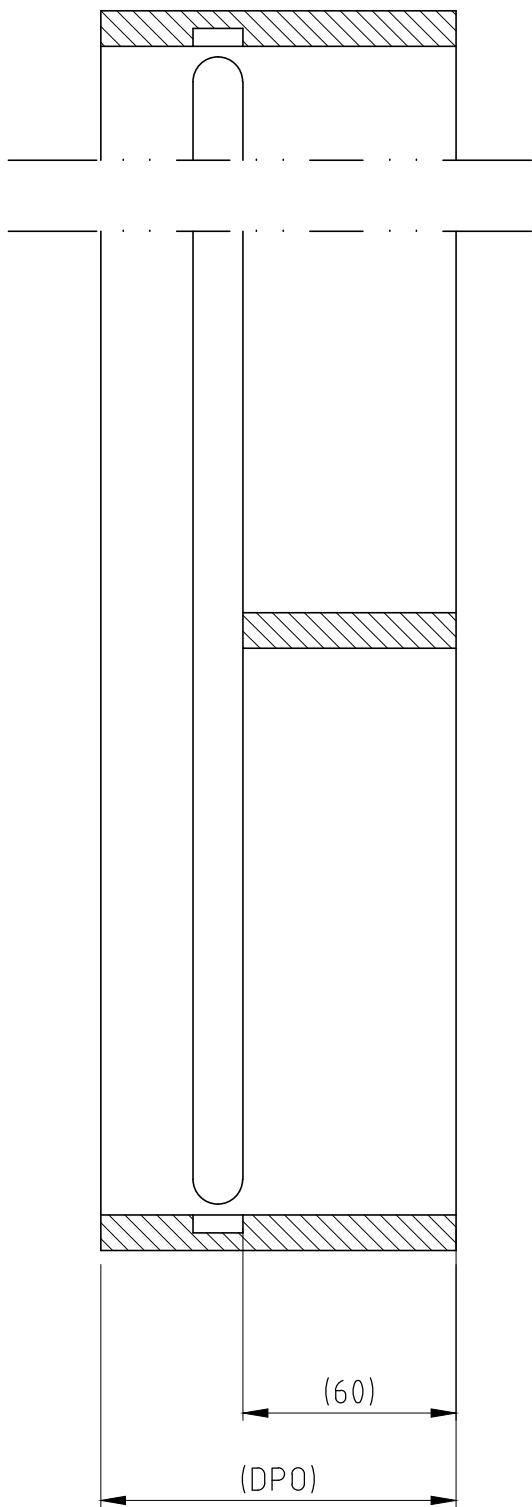


D	UPDATED TITLE BORDER	2019-05-02	se-linado
Rev	Type of revision	Date	Sign

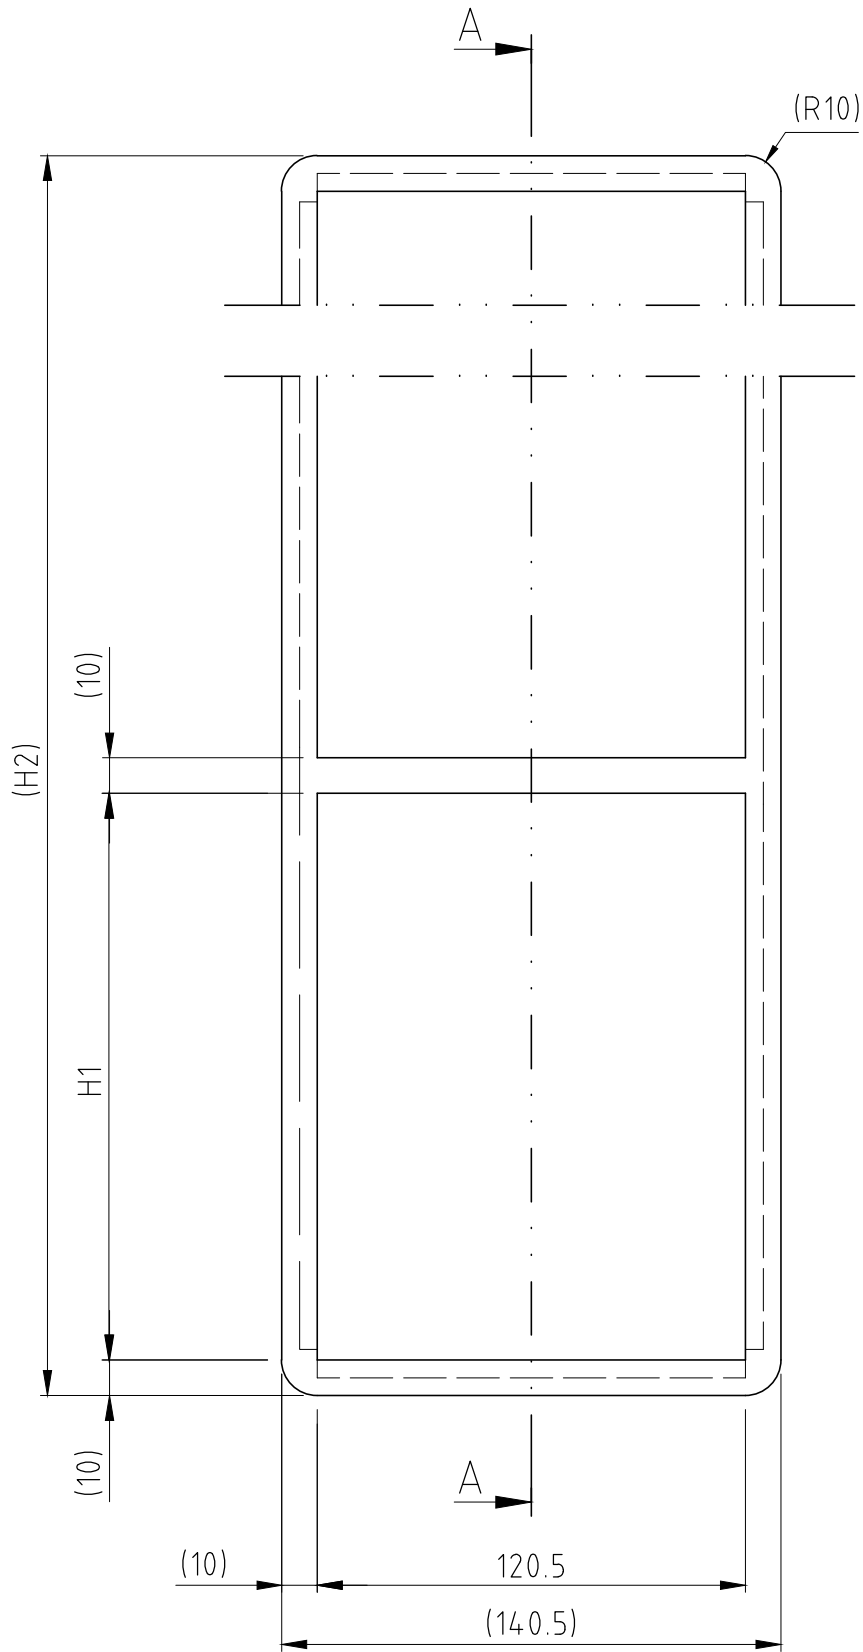

A - A

DPO = DIMENSION VIA PURCHASE ORDER
STANDARD DPO = 100MM

COMBINATION

TYPE	H1 (mm)	H2 (mm)
SK 2+2x1	101	232
SK 4+4x1	159.5	349
SK 6+6x1	218	466
SK 8+8x1	278	586
SK 2+2+2x1	101	343
SK 4+4+4x1	159.5	518.5
SK 6+6+6x1	218	694
SK 8+8+8x1	278	874
SK 2+2+2+2x1	101	454
SK 4+4+4+4x1	159.5	688
SK 6+6+6+6x1	218	922
SK 8+8+8+8x1	278	1162

SPECIAL COMBINATION

SIZE (mm)	H2 (mm)
H1	Rx(H1+10)+10

R=TOTAL NUMBERS OF ROWS

Item	Qty	Designation	Specification					NetWeight
General tolerances used for manufacturing shown in document DDC-00280		Designed by se-luckri	Created Date 2003-09-30	Latest save date 2019-05-07	Format A2	Scale 1:2	Sheet no	TotWeight -
 Roxtec www.roxtec.com		Title SK FRAME (M) + SINGLE FRAME Restricted due to Information drawing					Projection method 	Rev D
			Drawing number S1005384					