


烙克赛克保留所有权利。未经授权严禁复制，使用以及向第三方泄露。

All rights reserved. Unauthorized reproduction, use or disclosure to third parties is strictly forbidden.

Rev 2.0

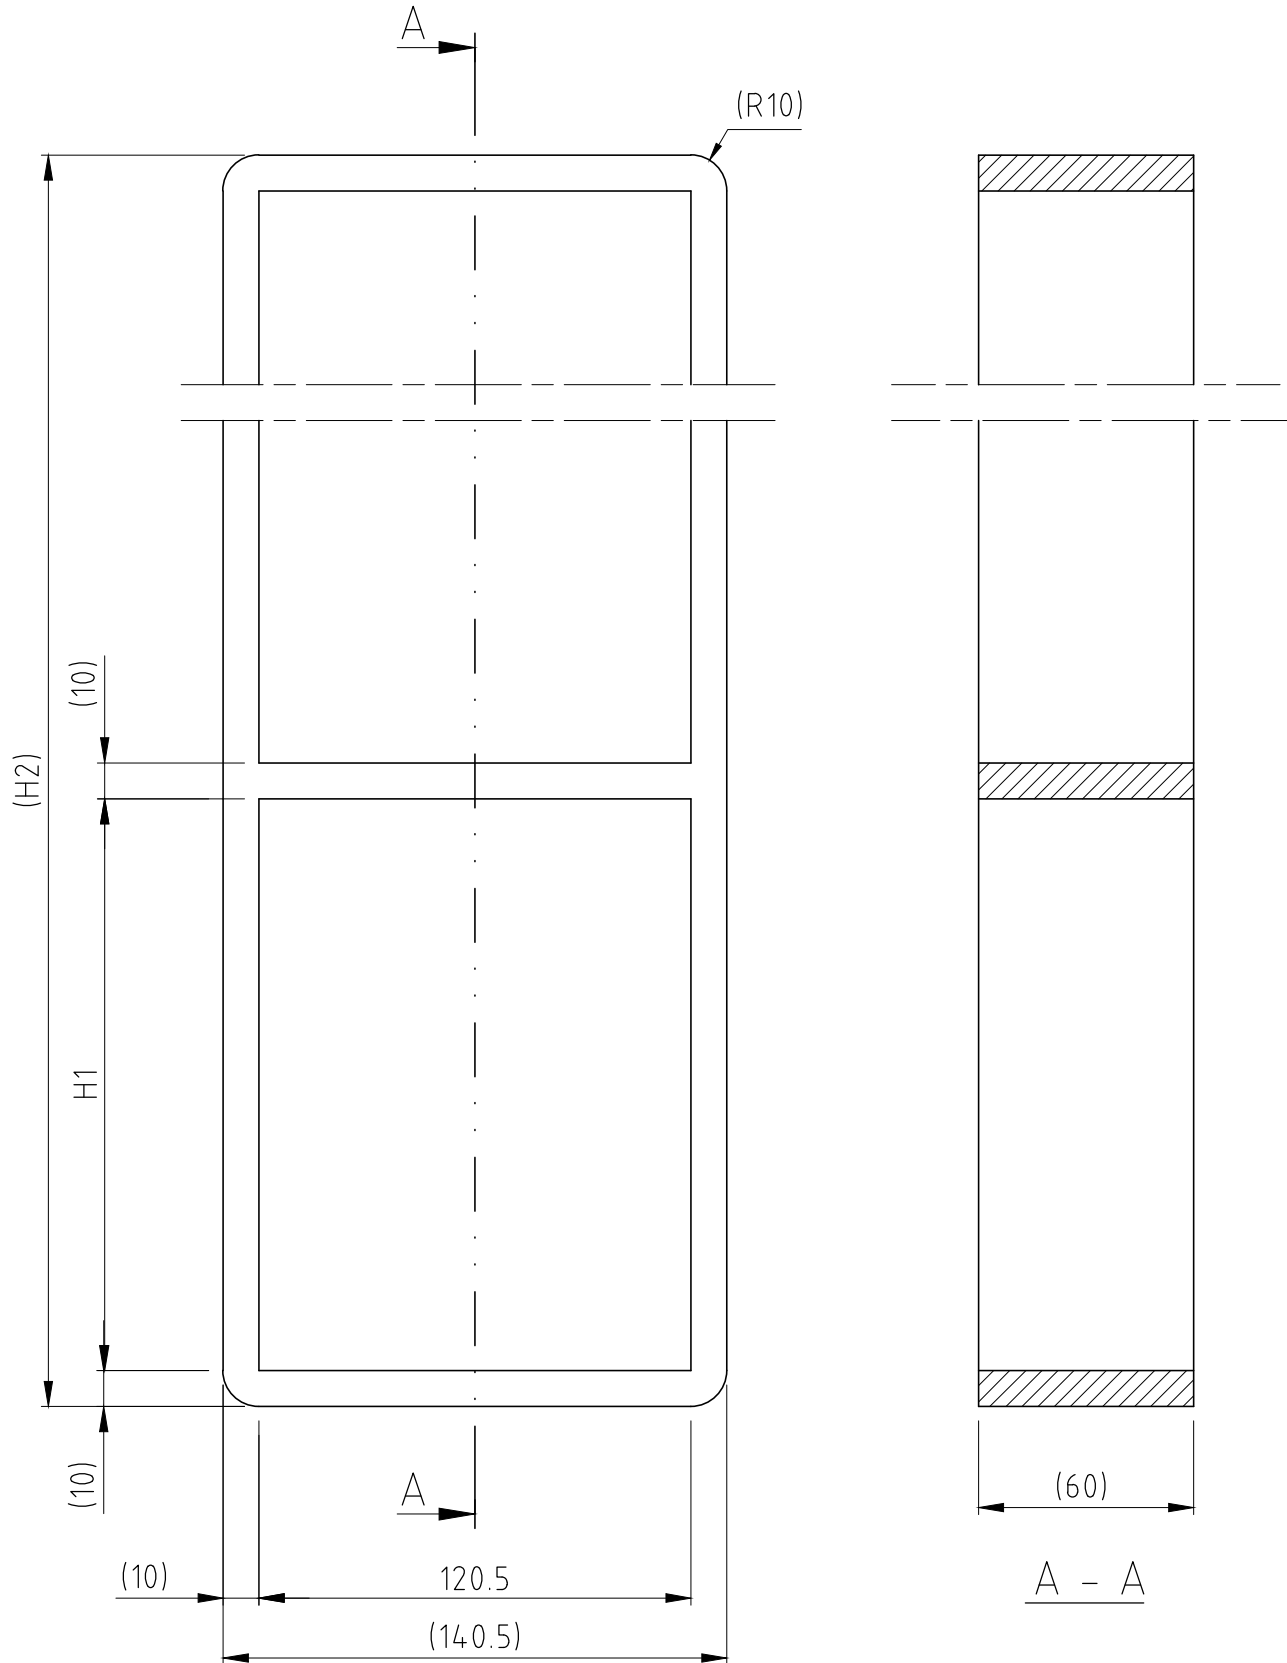

COMBINATION:

TYPE	H1 (mm)	H2 (mm)
S 2+2x1	101	232
S 4+4x1	159.5	349
S 6+6x1	218	466
S 8+8x1	278	586
S 2+2+2x1	101	343
S 4+4+4x1	159.5	518.5
S 6+6+6x1	218	694
S 8+8+8x1	278	874
S 2+2+2+2x1	101	454
S 4+4+4+4x1	159.5	688
S 6+6+6+6x1	218	922
S 8+8+8+8x1	278	1162

SPECIAL COMBINATION:

TYPE	H1 (mm)	R (NO OF ROWS)	H2 (mm)
S 2+2+2+...+2x1	101	R	111xR+10
S 4+4+4+...+4x1	159.5	R	169.5xR+10
S 6+6+6+...+6x1	218	R	228xR+10
S 8+8+8+...+8x1	278	R	288xR+10

C	UPDATED TITLE BORDER	2019-05-03	se-linado
Rev	Type of revision	Date	Sign

Item	Qty	Designation	Specification					NetWeight
General Tolerances used for manufacturing shown in document DDC-002180		Designed by se-luckri	Created Date 2003-11-03	Latest save date 2019-05-07	Format A3	Scale 1:2	Sheet no	TotWeight -
 Roxtec www.roxtec.com		Title S FRAME + SINGLE FRAME Restricted due to					Projection method 	Rev
Information drawing		Drawing number S1005523					C	

Information drawings show general design and nominal dimensions if not else stated