
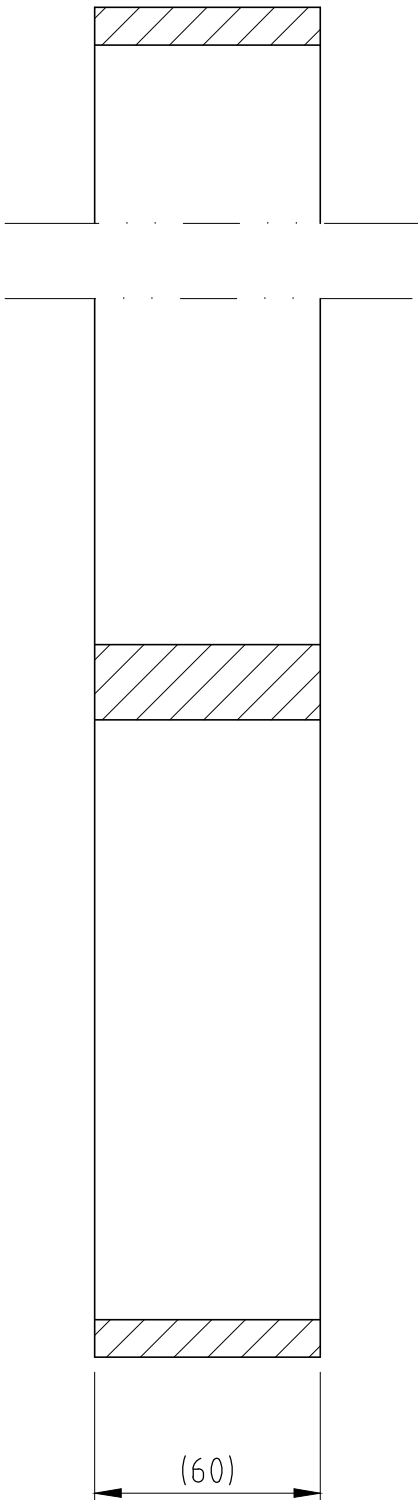


烙克赛克保留所有权利。未经授权严禁复制，使用以及向第三方泄露。

All rights reserved. Unauthorized reproduction, use or disclosure to third parties is strictly forbidden.

Rev 2.0

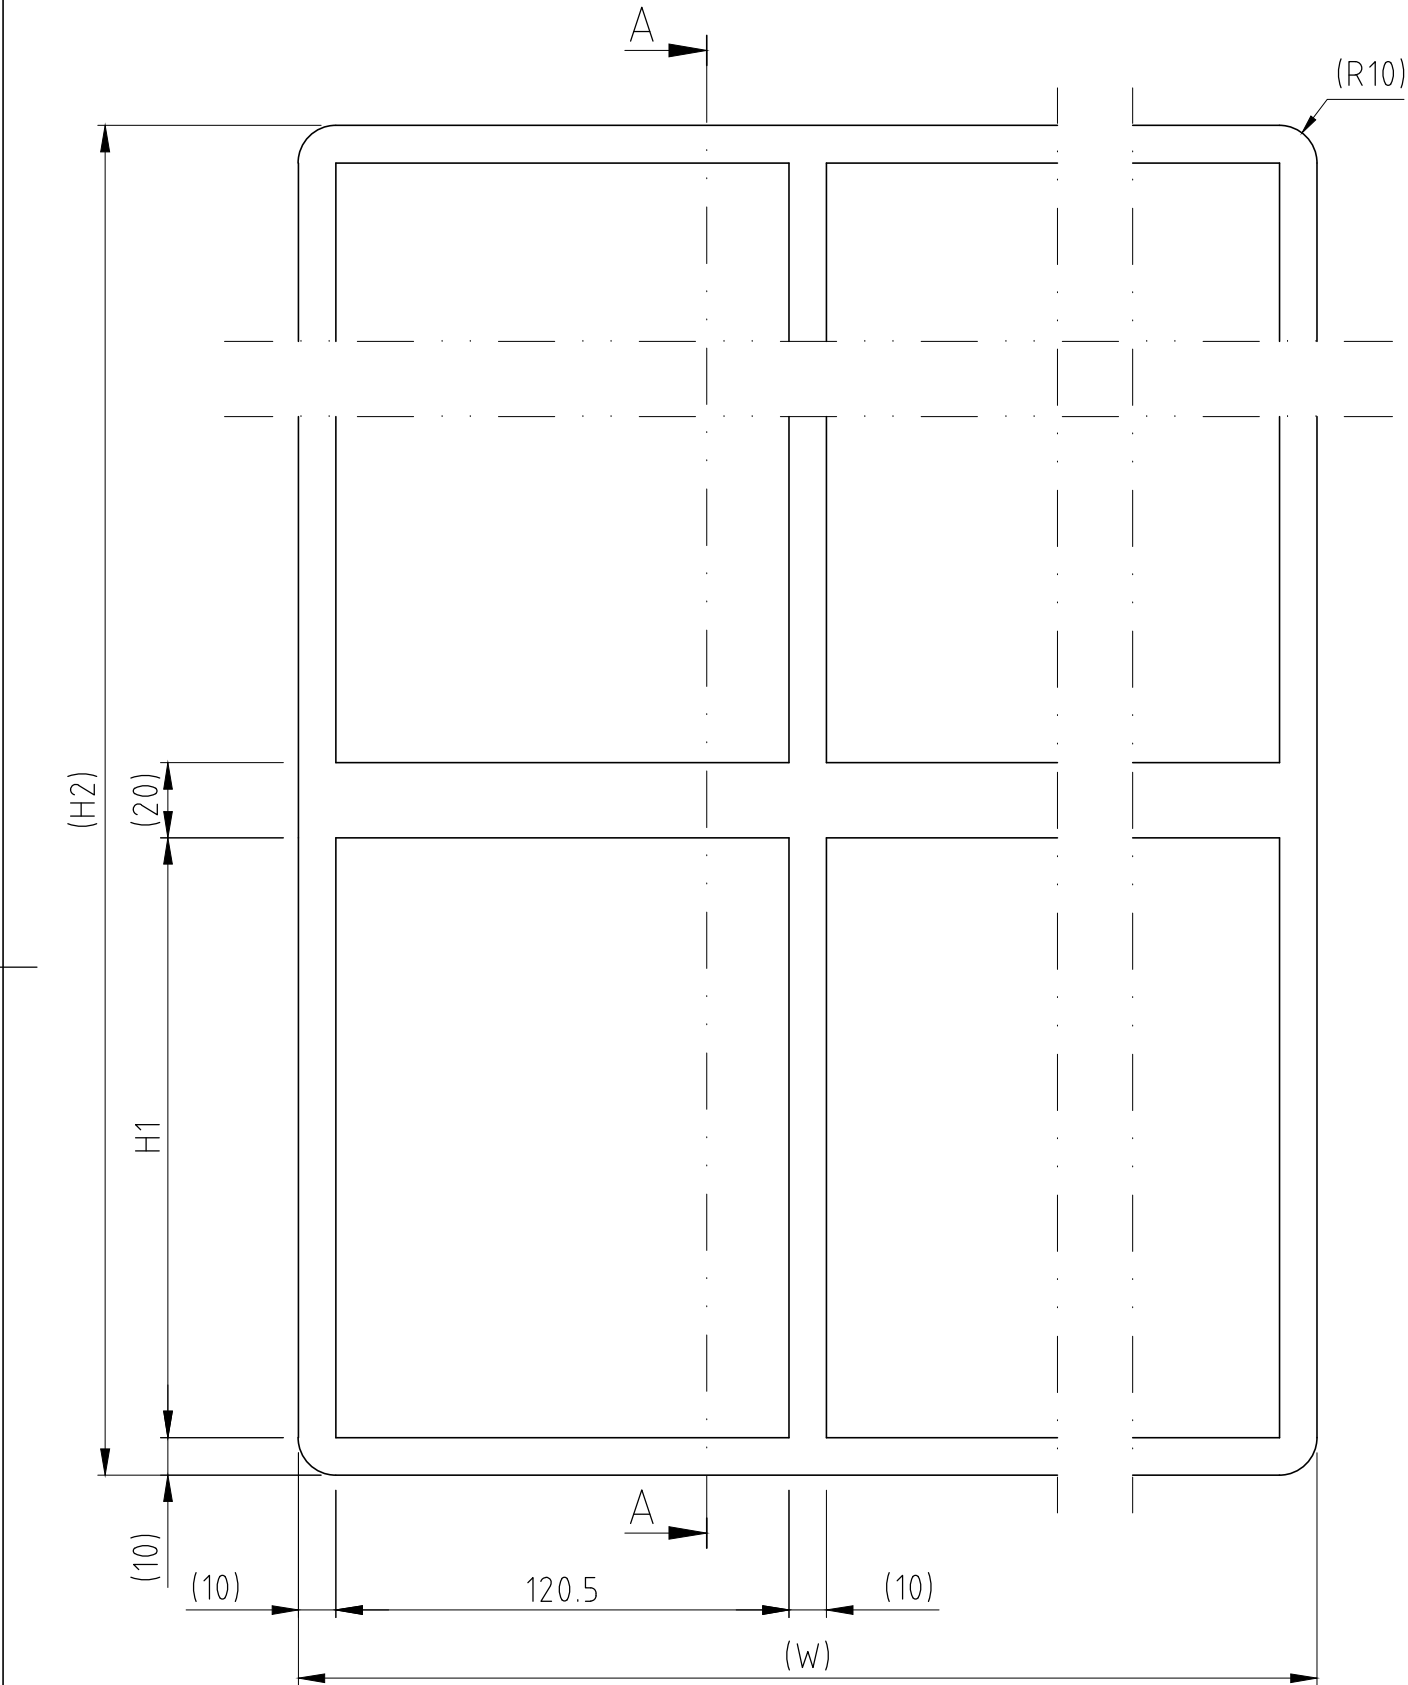

$A - A$

TYPE	H1 (mm)	H2 (mm)
S 2+2xN	101	242
S 4+4xN	159.5	359
S 6+6xN	218	476
S 8+8xN	278	596
S 2+2+2xN	101	363
S 4+4+4xN	159.5	538.5
S 6+6+6xN	218	714
S 8+8+8xN	278	894
S 2+2+2+2xN	101	484
S 4+4+4+4xN	159.5	718
S 6+6+6+6xN	218	952
S 8+8+8+8xN	278	1192

COMB.	W (mm)
x2	271
x3	401.5
x4	532
x5	662.5
x6	793
x7	923.5
x8	1054
x9	1184.5
x10	1315

R=TOTAL NUMBERS OF ROWS

D	UPDATED TITLE BORDER	2019-05-03	se-linado
Rev	Type of revision	Date	Sign

Item	Qty	Designation	Specification					Net Weight
General tolerances used for manufacturing shown in document DDC-002180		Designed by se-luckri	Created Date 2003-11-03	Latest save date 2019-05-03	Format A3	Scale 1:2	Sheet no	Tot Weight -
 www.roxtec.com		Title S FRAME + COMBINATION FRAME					Projection method 	
		Restricted due to Information drawing					Drawing number S1005525	Rev D

Information drawings show general design and nominal dimensions if not else stated