
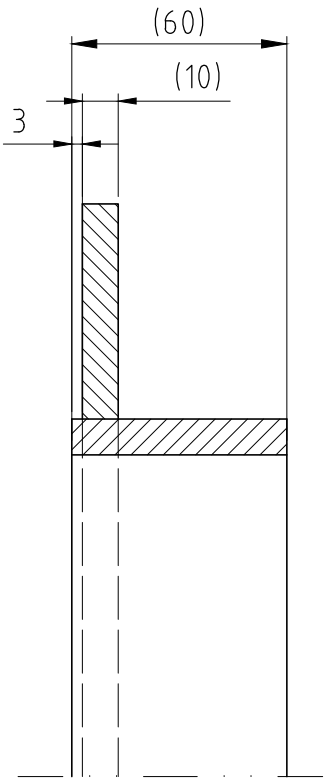


烙克赛克保留所有权利。未经授权严禁复制，使用以及向第三方泄露。

All rights reserved. Unauthorized reproduction, use or disclosure to third parties is strictly forbidden.

Rev 2.0

|     |                      |            |           |
|-----|----------------------|------------|-----------|
| B   | UPDATED TITLE BORDER | 2019-05-03 | se-linado |
| Rev | Type of revision     | Date       | Sign      |

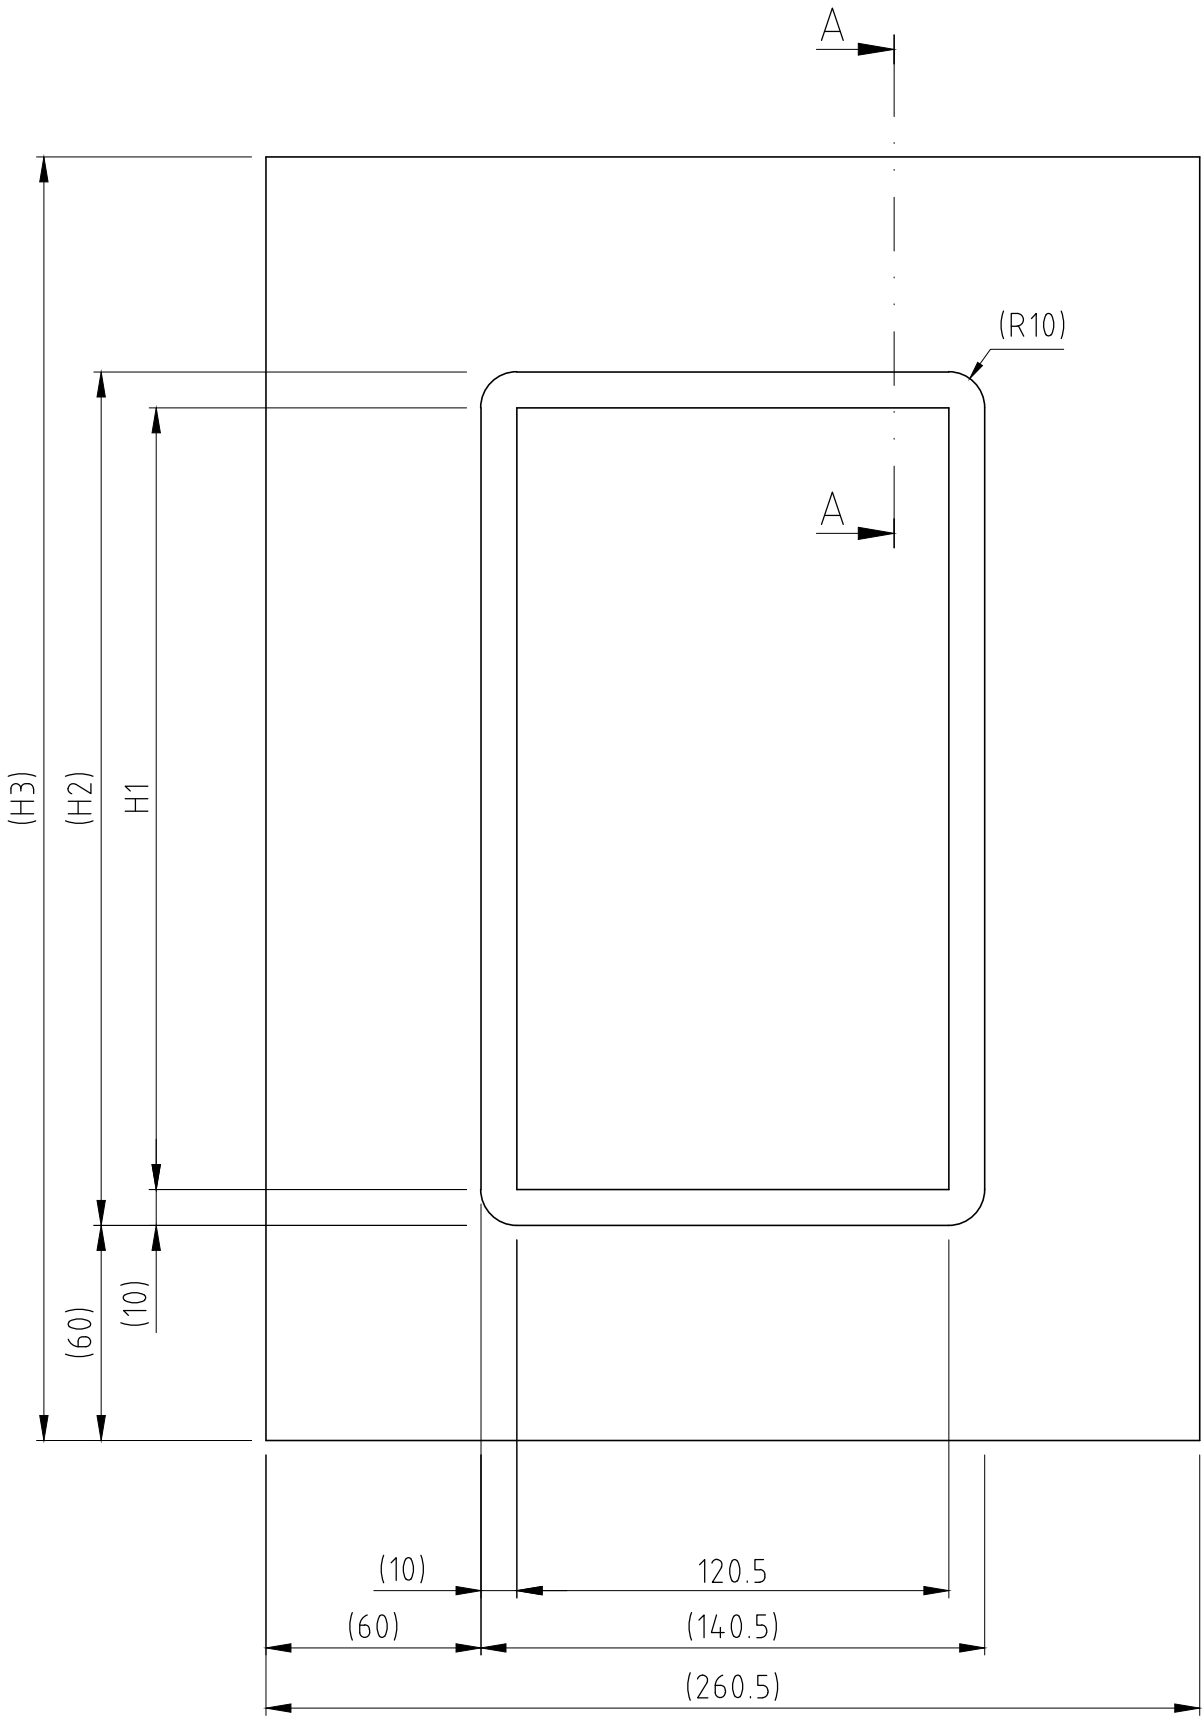

A - A

| TYPE   | H1 (mm) | H2 (mm) | H3 (mm) |
|--------|---------|---------|---------|
| SF 2x1 | 101     | 121     | 241     |
| SF 4x1 | 159.5   | 179.5   | 299.5   |
| SF 6x1 | 218     | 238     | 358     |
| SF 8x1 | 278     | 298     | 418     |

| Item                                                                                                    | Qty | Designation | Specification                                          |                            |                                |              |              |          | NetWeight                                                                                                  |
|---------------------------------------------------------------------------------------------------------|-----|-------------|--------------------------------------------------------|----------------------------|--------------------------------|--------------|--------------|----------|------------------------------------------------------------------------------------------------------------|
| General Tolerances used for manufacturing shown in document DDC-002180                                  |     |             | Designed by<br>se-joahel                               | Created Date<br>2003-11-03 | Latest save date<br>2019-05-07 | Format<br>A3 | Scale<br>1:2 | Sheet no | TotWeight<br>-                                                                                             |
| <br>www.roxtec.com |     |             | Title<br>SF FRAME<br>SINGLE FRAME<br>Restricted due to |                            |                                |              |              |          | Projection method<br> |
| Information drawing                                                                                     |     |             | Drawing number<br>S1005529                             |                            |                                |              |              |          | Rev<br>B                                                                                                   |

Information drawings show general design and nominal dimensions if not else stated