
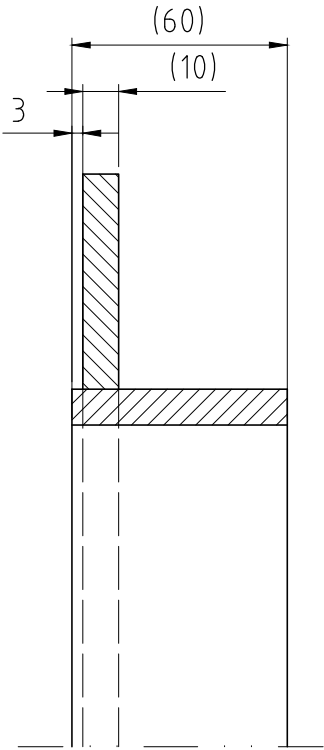


烙克赛克保留所有权利。未经授权严禁复制，使用以及向第三方泄漏。

All rights reserved. Unauthorized reproduction, use or disclosure to third parties is strictly forbidden.

Rev 2.0

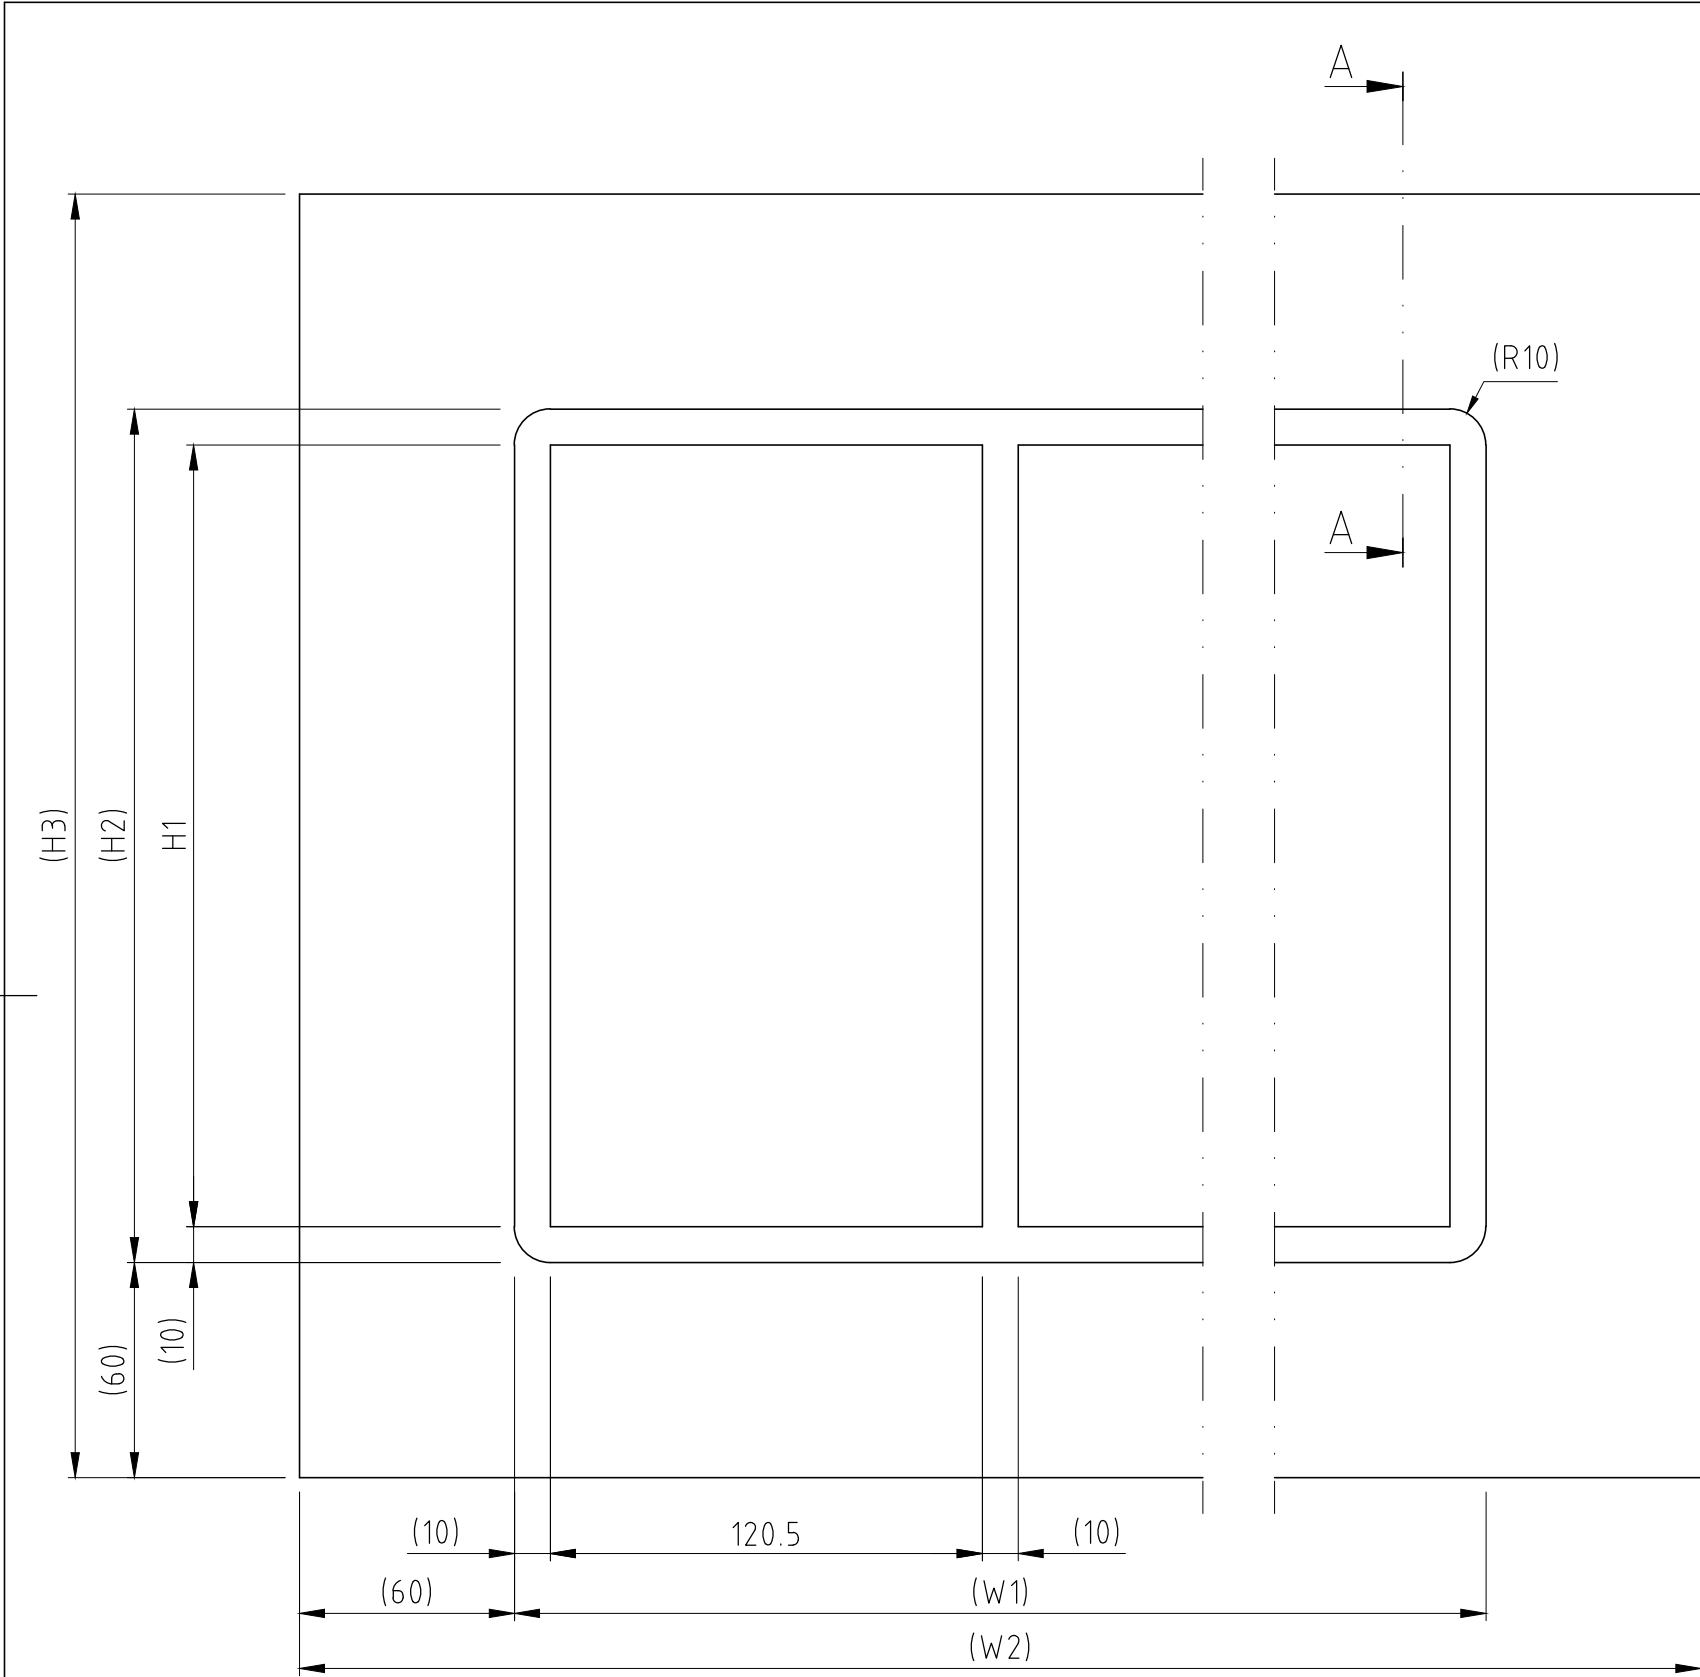

SIZE:

TYPE	H1 (mm)	H2 (mm)	H3 (mm)
SF 2xN	101	121	241
SF 4xN	159.5	179.5	299.5
SF 6xN	218	238	358
SF 8xN	278	298	418

STANDARD WIDTH:

COMB. (xN)	W1 (mm)	W2 (mm)
x2	271	391
x3	401.5	521.5
x4	532	652
x5	662.5	782.5
x6	793	913
x7	923.5	1043.5
x8	1054	1174
x9	1184.5	1304.5
x10	1315	1435

F	UPDATED TITLE BORDER	2019-05-03	se-linado
Rev	Type of revision	Date	Sign

Item	Qty	Designation	Specification						NetWeight
General tolerances used for manufacturing shown in document DDC-002180			Designed by se-luckri	Created Date 2003-11-03	Latest save date 2019-05-07	Format A3	Scale 1:2	Sheet no	TotWeight -
 Roxtec www.roxtec.com			Title SF FRAME COMBINATION FRAME						Projection method 
			Restricted due to Information drawing				Drawing number S1005530		Rev F

Information drawings show general design and nominal dimensions if not else stated