
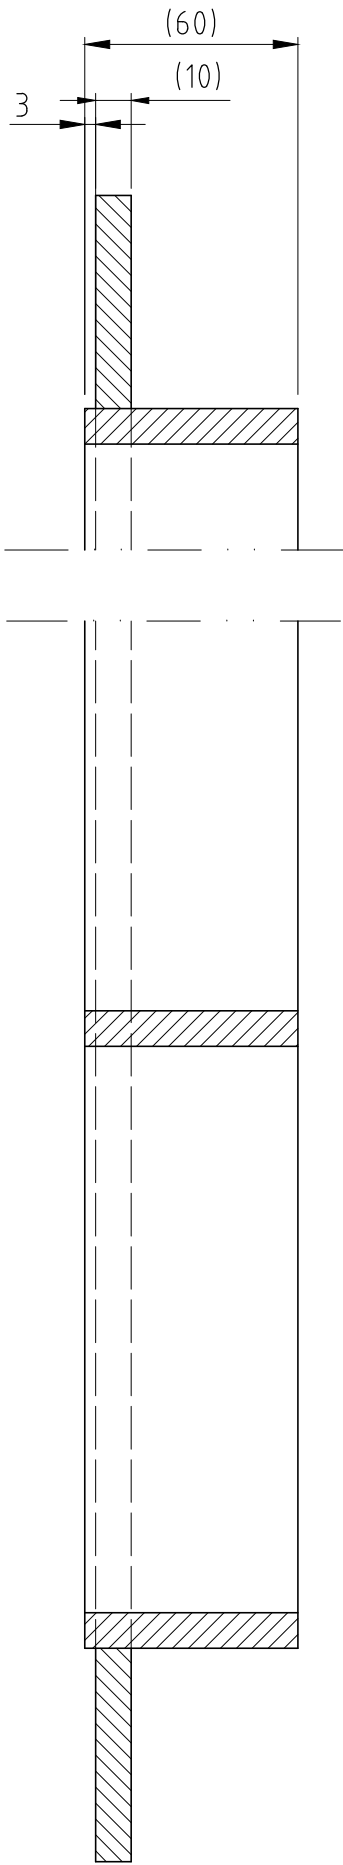


C	UPDATED TITLE BORDER	2019-05-03	se-linado
Rev	Type of revision	Date	Sign

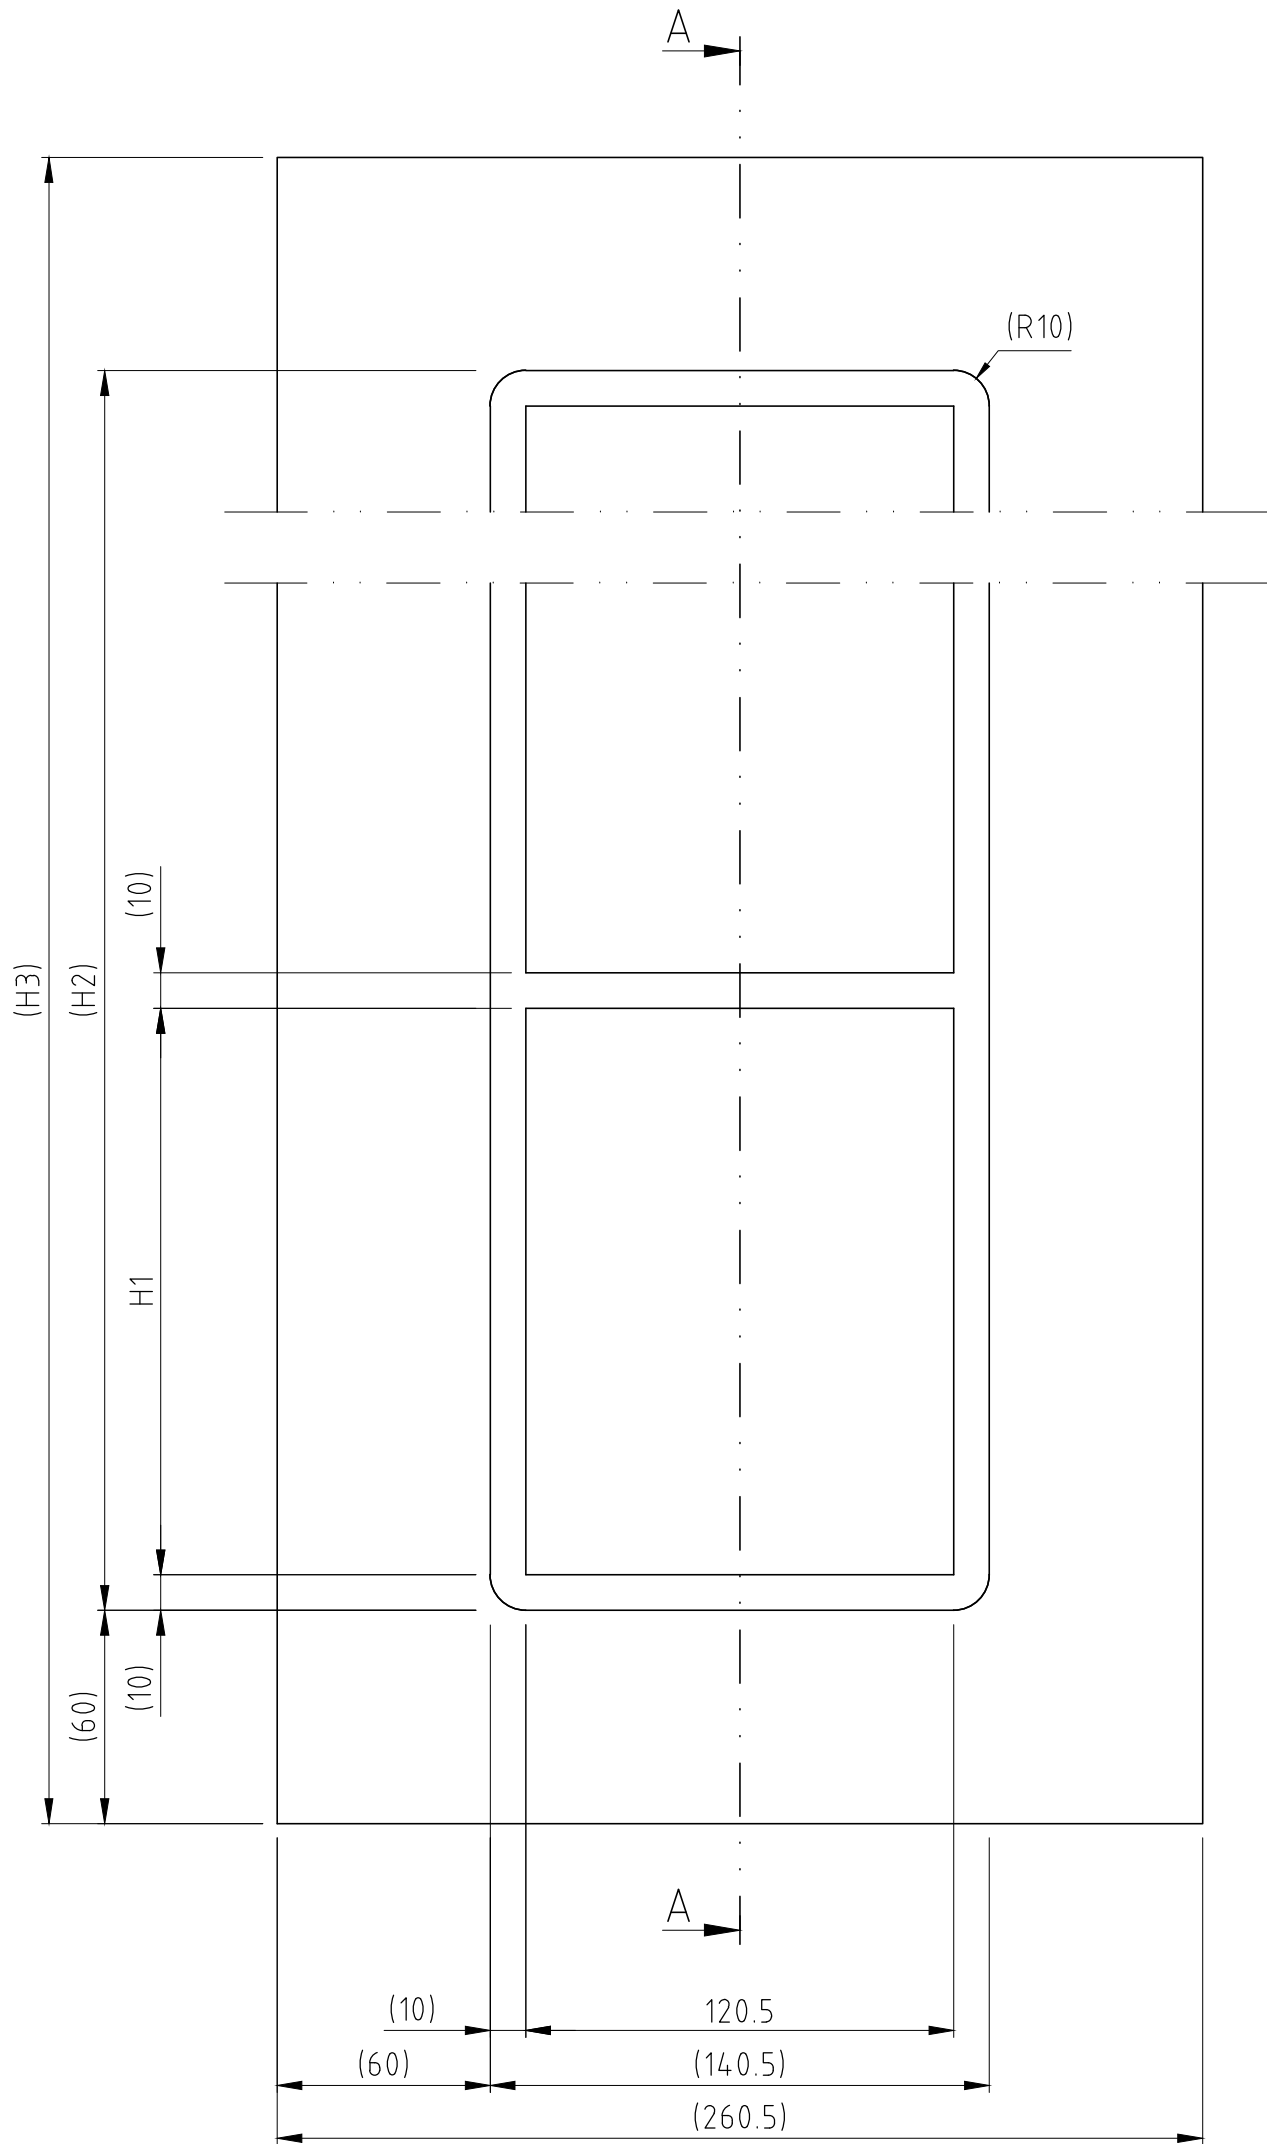

A - A

COMBINATION			
TYPE	H1 (mm)	H2 (mm)	H3 (mm)
SF 2+2x1	101	232	352
SF 4+4x1	159,5	349	469
SF 6+6x1	218	466	586
SF 8+8x1	278	586	706
SF 2+2+2x1	101	343	463
SF 4+4+4x1	159,5	518.5	638.5
SF 6+6+6x1	218	694	814
SF 8+8+8x1	278	874	994
SF 2+2+2+2x1	101	454	574
SF 4+4+4+4x1	159,5	688	808
SF 6+6+6+6x1	218	922	1042
SF 8+8+8+8x1	278	1162	1282

SPECIAL COMBINATION				
TYPE	H1 (mm)	R (NO OF ROWS)	H2 (mm)	H3 (mm)
SF 2+2+2+...+2x1	101	R	111xR+10	H2+120
SF 4+4+4+...+4x1	159,5	R	169.5xR+10	H2+120
SF 6+6+6+...+6x1	218	R	228xR+10	H2+120
SF 8+8+8+...+8x1	278	R	288xR+10	H2+120

Item	Qty	Designation	Specification						NetWeight
General tolerances used for manufacturing shown in document DDC-00280			Designed by se-luckri	Created Date 2003-11-03	Latest save date 2019-05-09	Format A2	Scale 1:2	Sheet no	TotWeight
 www.roxtec.com			Title SF FRAME + SINGLE FRAME Restricted due to						Projection method 
			Drawing number S1005532						Rev C