


烙克赛克保留所有权利。未经授权严禁复制，
使用以及向第三方泄漏。

All rights reserved. Unauthorized reproduction, use
or disclosure to third parties is strictly forbidden.


 
Rev 2.0

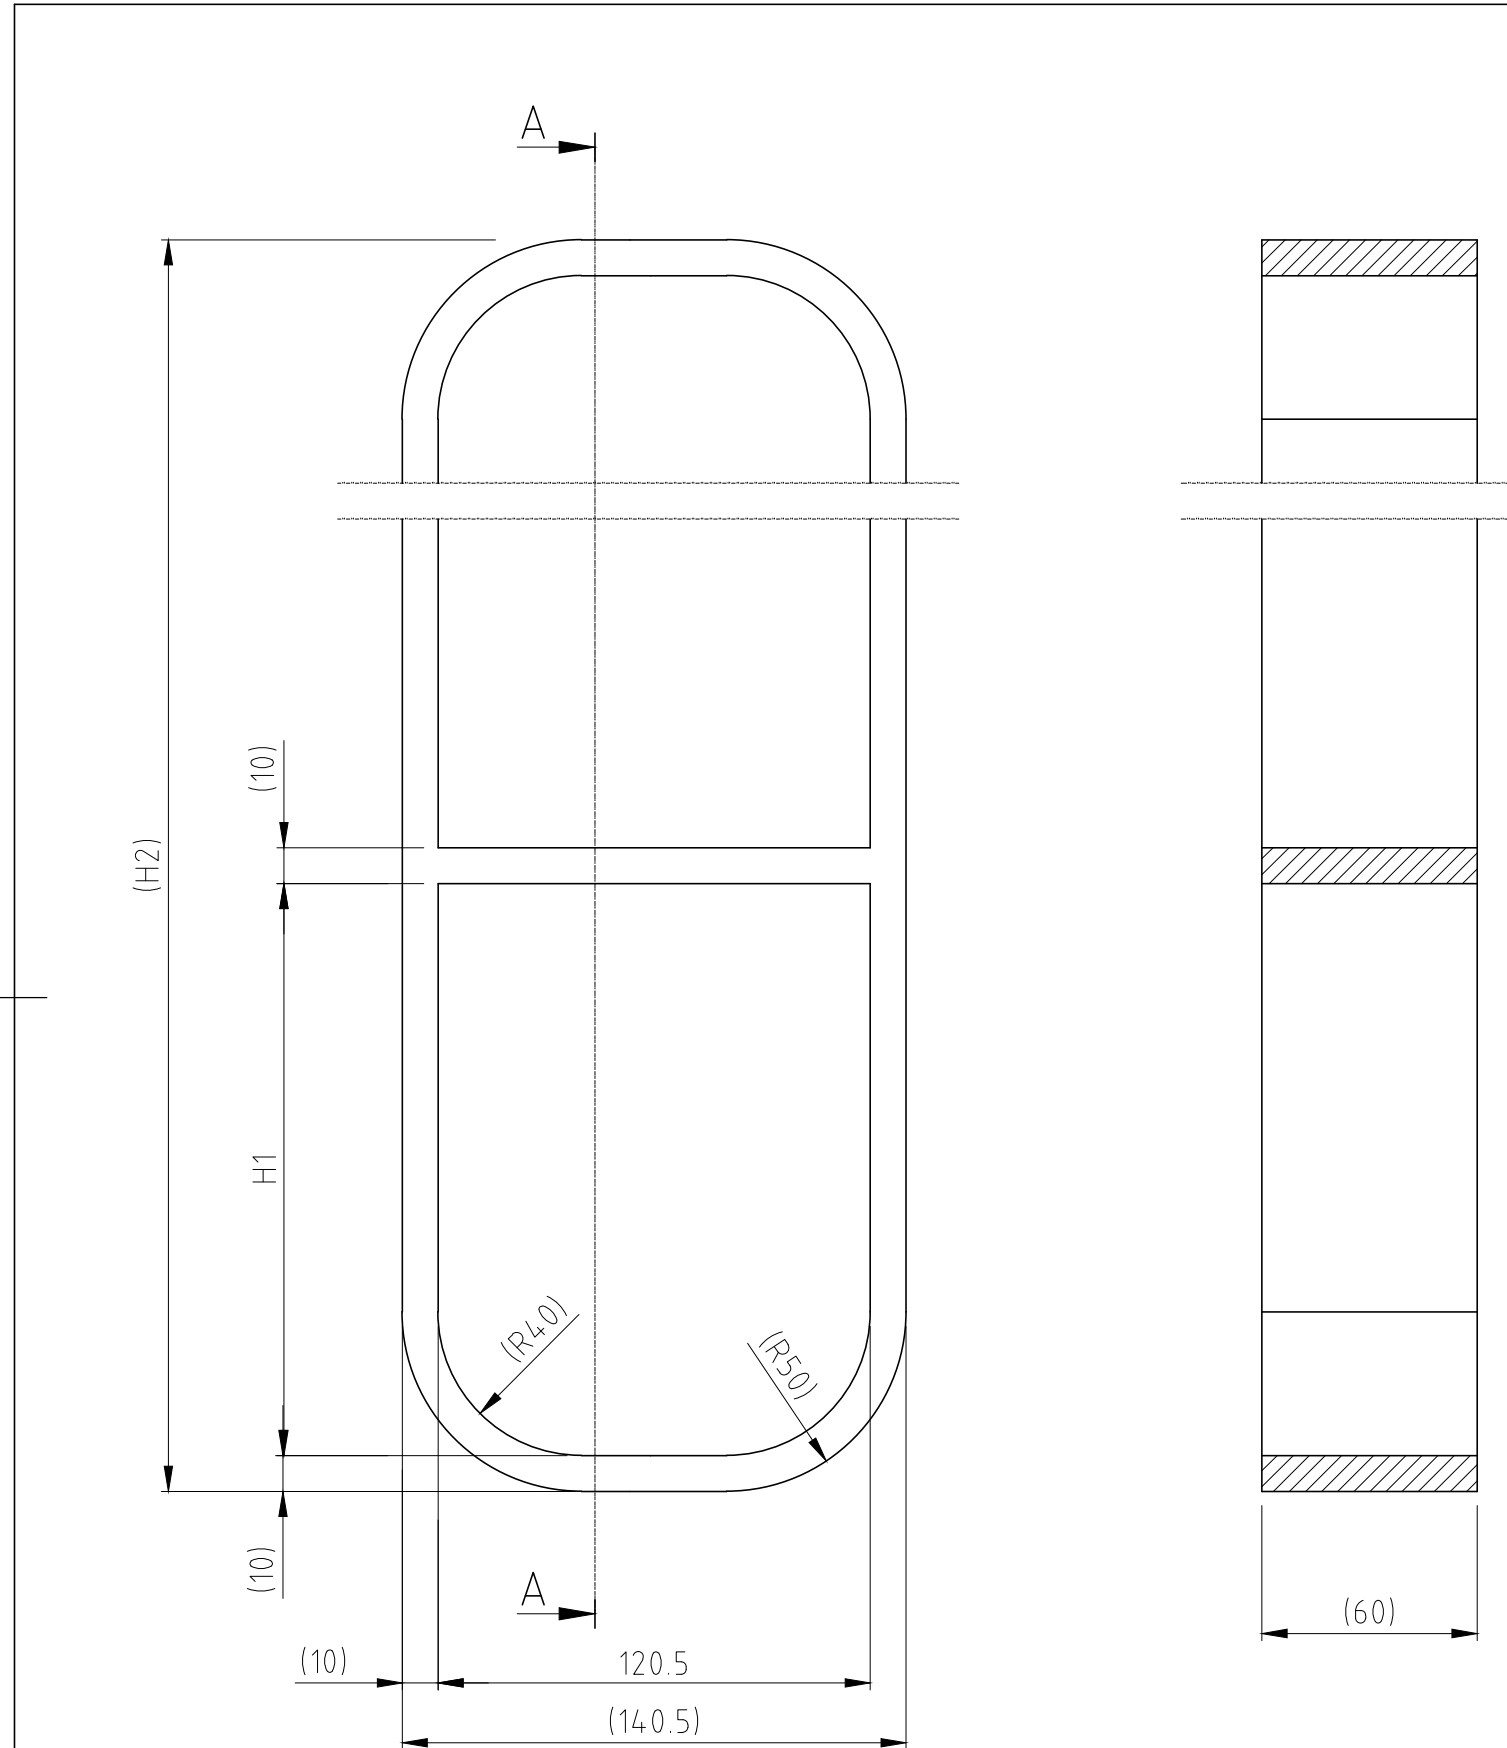

| TYPE | H1 (mm) | H2 (mm) |
|-------------------|---------|---------|
| SRC 4+4x1 R40 | 159.5 | 349 |
| SRC 6+6x1 R40 | 218 | 466 |
| SRC 8+8x1 R40 | 278 | 586 |
| SRC 4+4+4x1 R40 | 159.5 | 518.5 |
| SRC 6+6+6x1 R40 | 218 | 694 |
| SRC 8+8+8x1 R40 | 278 | 874 |
| SRC 4+4+4+4x1 R40 | 159.5 | 688 |
| SRC 6+6+6+6x1 R40 | 218 | 922 |
| SRC 8+8+8+8x1 R40 | 278 | 1162 |

A - A

| Rev | Type of revision | Date | Sign |
|-----|----------------------|------------|-----------|
| B | UPDATED TITLE BORDER | 2019-05-02 | se-linado |

| Item | Qty | Designation | Specification | | | | | NetWeight |
|---|-----|--|----------------------------|--|--------------|--|----------|----------------------------|
| General tolerances used for manufacturing shown in document DDC-002180 | | Designed by se-joahel | Created Date 2003-11-03 | Latest save date 2019-05-07 | Format A3 | Scale 1:2 | Sheet no | TotWeight - |
|  www.roxtec.com | | Title SRC FRAME + SINGLE FRAME R40 | | Projection method  | | Restricted due to Information drawing | | Drawing number S1005542 |
| | | | | | | | Rev B | |

Information drawings show general design and nominal dimensions if not else stated