
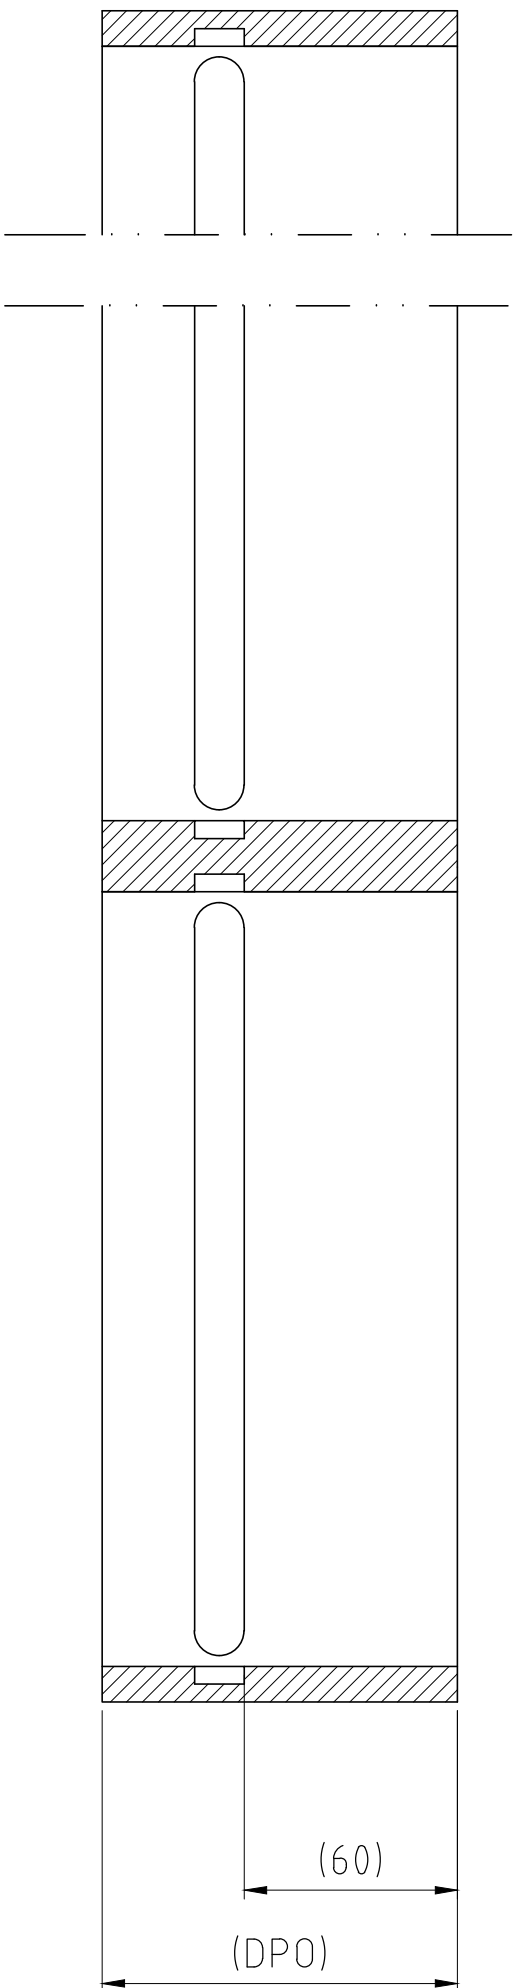


B	UPDATED TITLE BORDER	2019-05-02	se-linado
Rev	Type of revision	Date	Sign

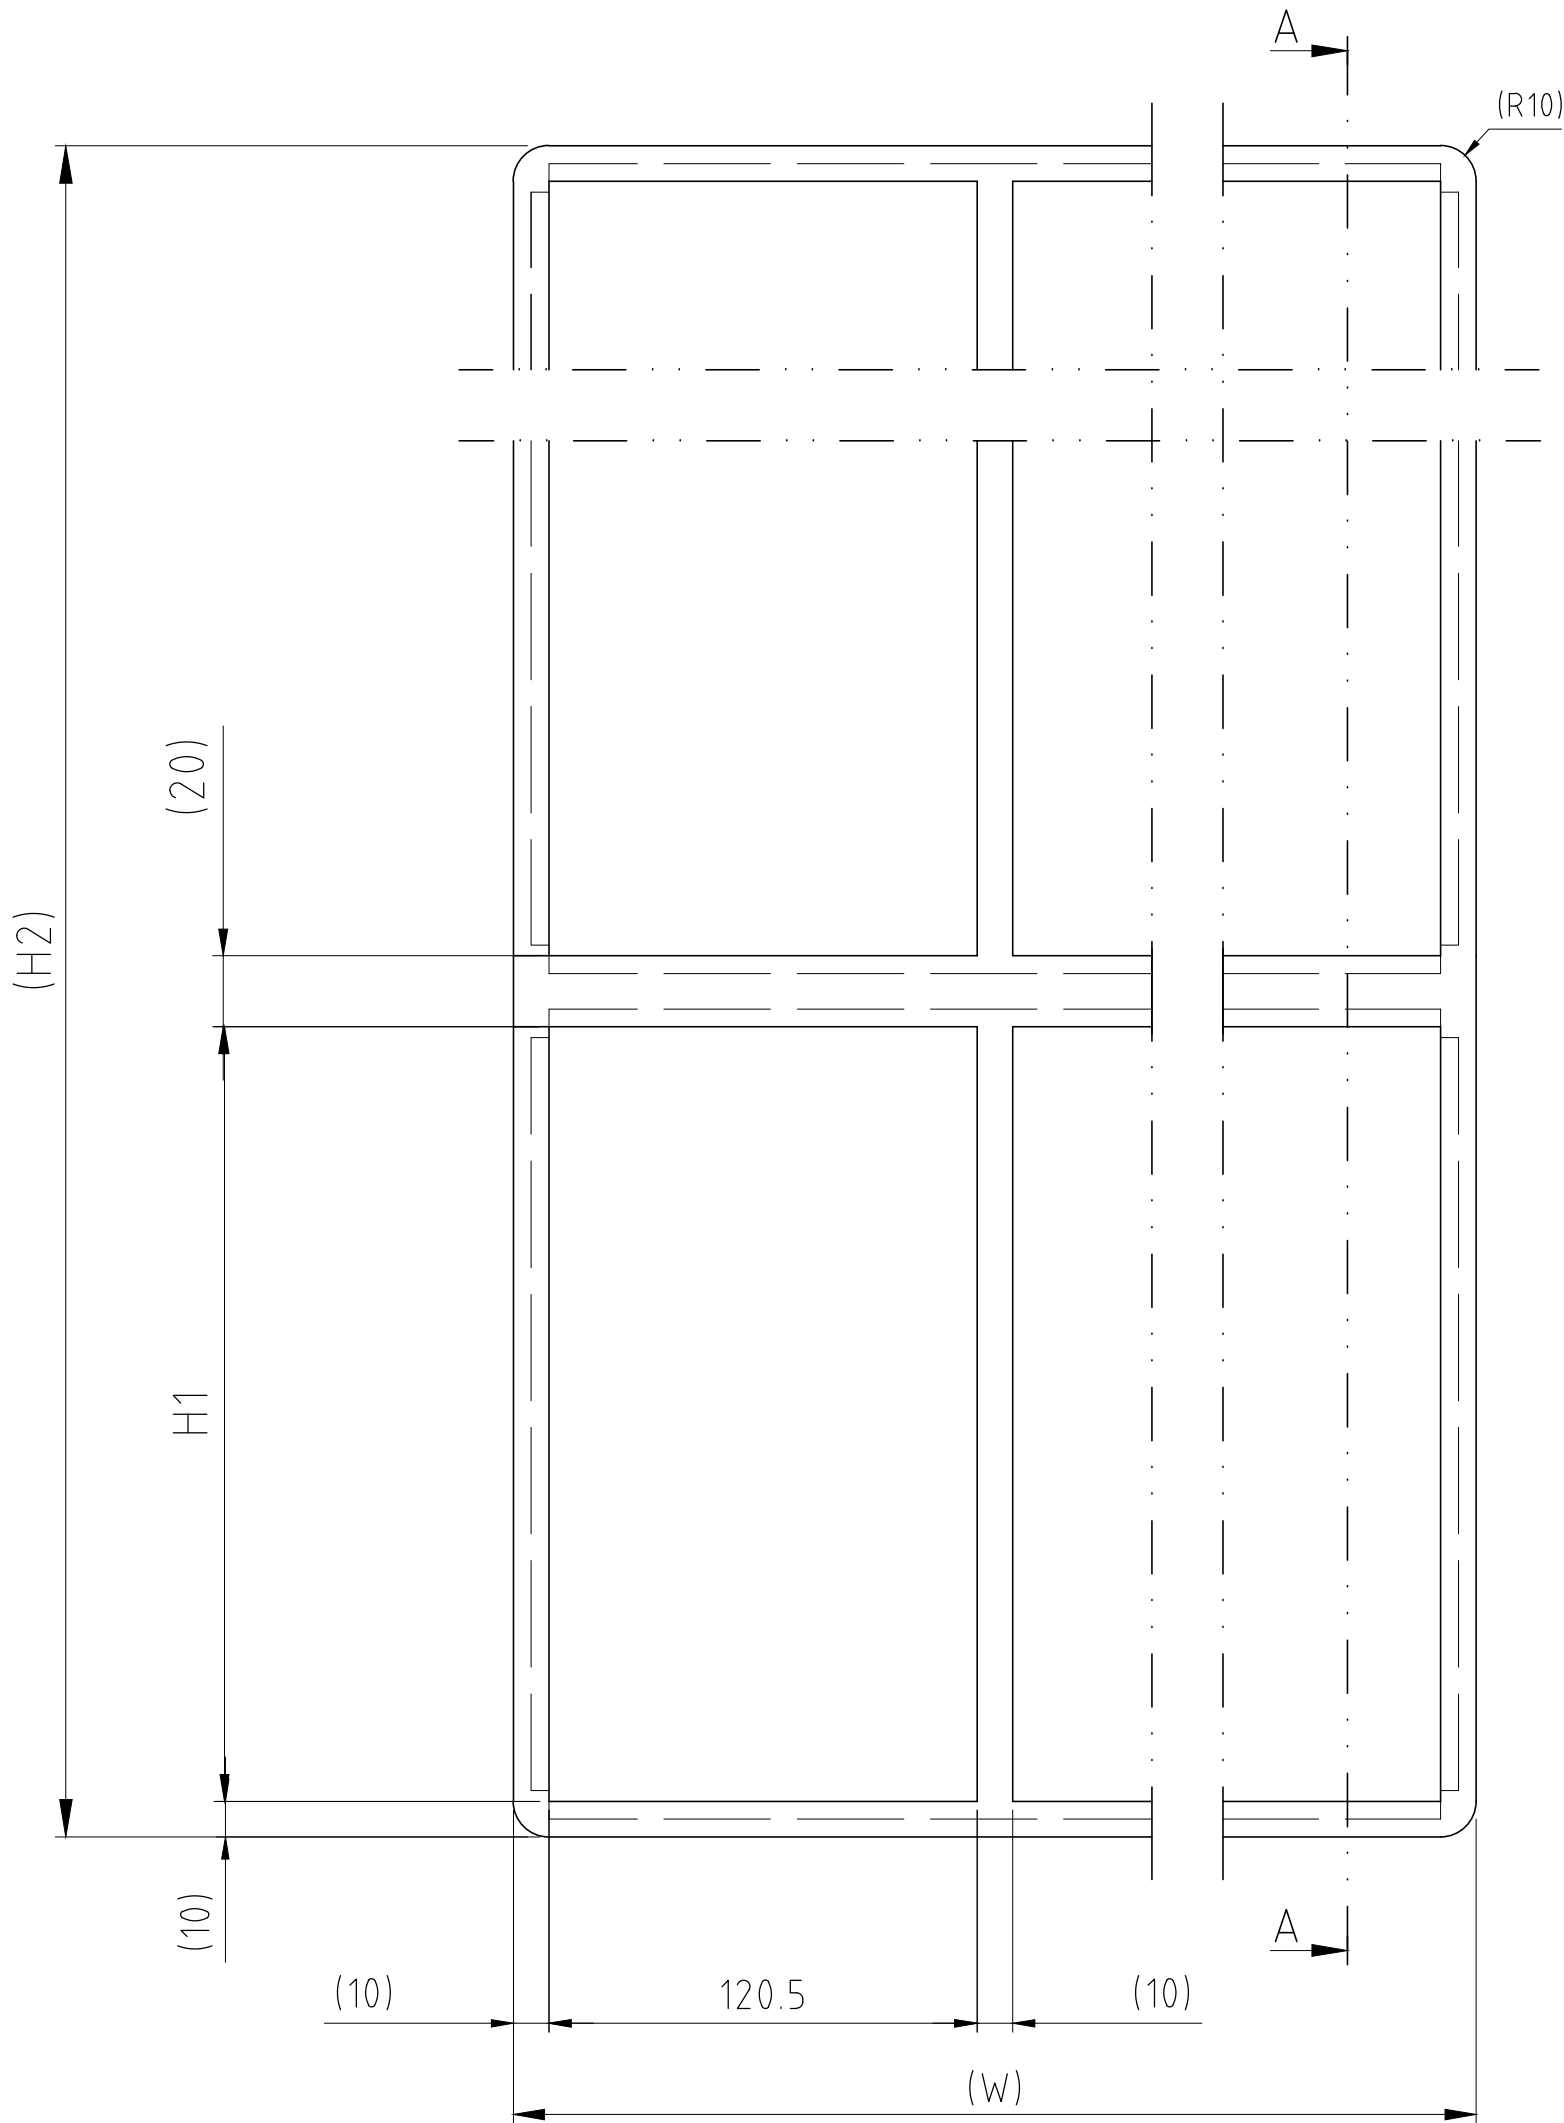

A – A

DPO = DIMENSION VIA PURCHASE ORDER
 STANDARD DPO = 100MM

COMBINATION

TYPE	H1 (mm)	H2 (mm)
SK 2+2xN	101	242
SK 4+4 xN	159.5	359
SK 6+6xN	218	476
SK 8+8xN	278	596
SK 2+2+2xN	101	363
SK 4+4+4 xN	159.5	538.5
SK 6+6+6xN	218	714
SK 8+8+8xN	278	894
SK 2+2+2+2xN	101	484
SK 4+4+4+4 xN	159.5	718
SK 6+6+6+6xN	218	952
SK 8+8+8+8xN	278	1192

WIDTH.

TYPE	W (mm)
x2	271
x3	401.5
x4	532
x5	662.5
x6	793
x7	923.5
x8	1054
x9	1184.5
x10	1315

SPECIAL COMBINATION:

COMB.	SIZE (mm)	W (mm)	H2 (mm)
xN	H1	130,5xN+10	Rx(H1+20)

R=TOTAL NUMBERS OF ROWS

Item	Qty	Designation	Specification						NetWeight
General tolerances used for manufacturing shown in document DDC-00280			Designed by se-luckri	Created Date 2006-12-21	Latest save date 2019-05-07	Format A2	Scale 1:2	Sheet no	TotWeight -
 www.roxtec.com			Title SK FRAME (M) + COMBINATION FRAME Restricted due to						Projection method 
			Information drawing			Drawing number S1010355			Rev B