
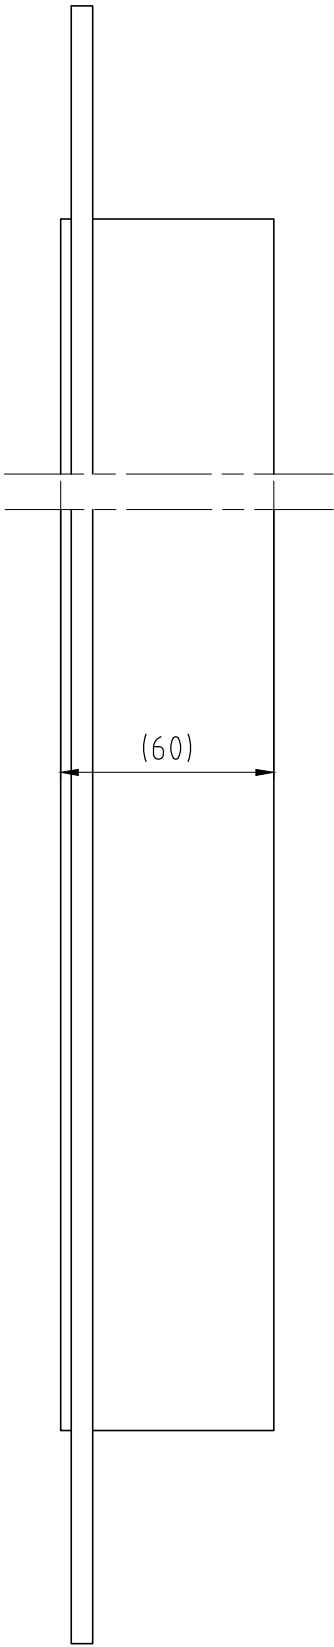


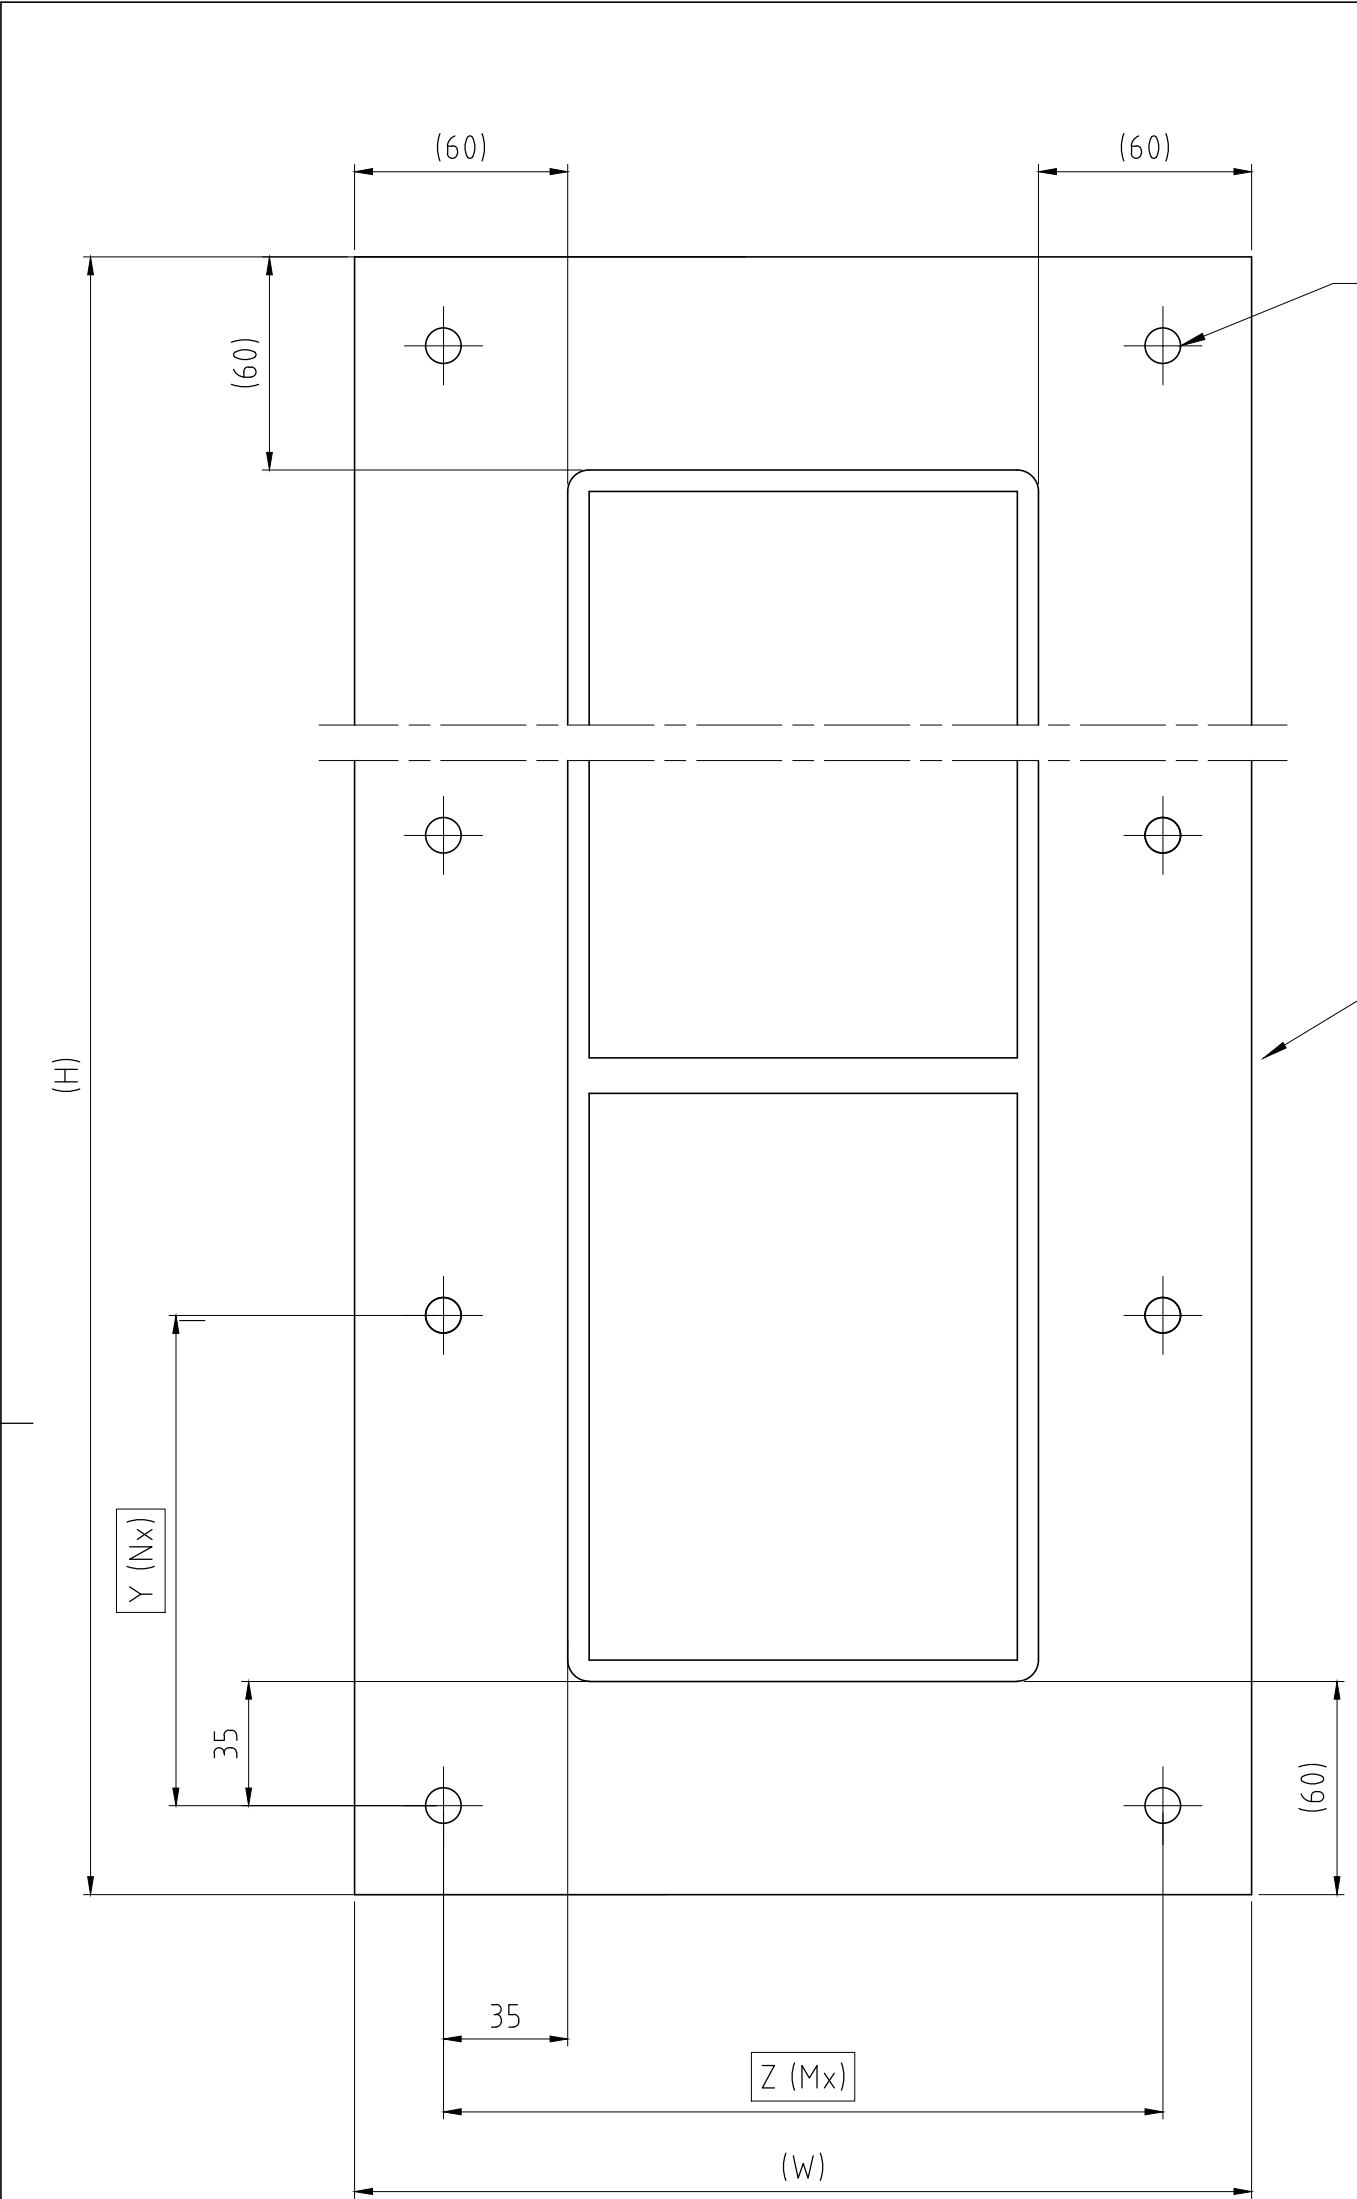

TYPE	H	W	Z	M	Y	N	P
GH 2+2x1	344	252,5	202,5	1	147	2	6
GH 4+4x1	461	252,5	202,5	1	137	3	8
GH 6+6x1	578	252,5	202,5	1	176	3	8
GH 8+8x1	698	252,5	202,5	1	162	4	10

TYPE	H	W	Z	M	Y	N	P
GH 2+2+2x1	455	252,5	202,5	1	135	3	8
GH 4+4+4x1	630,5	252,5	202,5	1	145,1	4	10
GH 6+6+6x1	806	252,5	202,5	1	151,2	5	12
GH 8+8+8x1	986	252,5	202,5	1	156	6	14

TYPE	H	W	Z	M	Y	N	P
GH 2+2+2+2x1	566	252,5	202,5	1	172	3	8
GH 4+4+4+4x1	800	252,5	202,5	1	150	5	12
GH 6+6+6+6x1	1034	252,5	202,5	1	164	6	14
GH 8+8+8+8x1	1274	252,5	202,5	1	153	8	18

B	UPDATED TITLE BORDER	2019-05-03	se-linado
Rev	Type of revision	Date	Sign

1	1	+ SINGLE FRAME	S1005560					
Item	Qty	Designation	Specification					NetWeight
General tolerances used for manufacturing shown in document DDC-00280		Designed by	Created Date	Latest save date	Format	Scale	Sheet no	TotWeight
		se-ronpet	2007-01-02	2019-05-07	A2	1:2		-
 Roxtec www.roxtec.com		Title GH FRAME + SINGLE FRAME						Projection method
		Restricted due to Information drawing					Drawing number	Rev
					S1010381		B	