


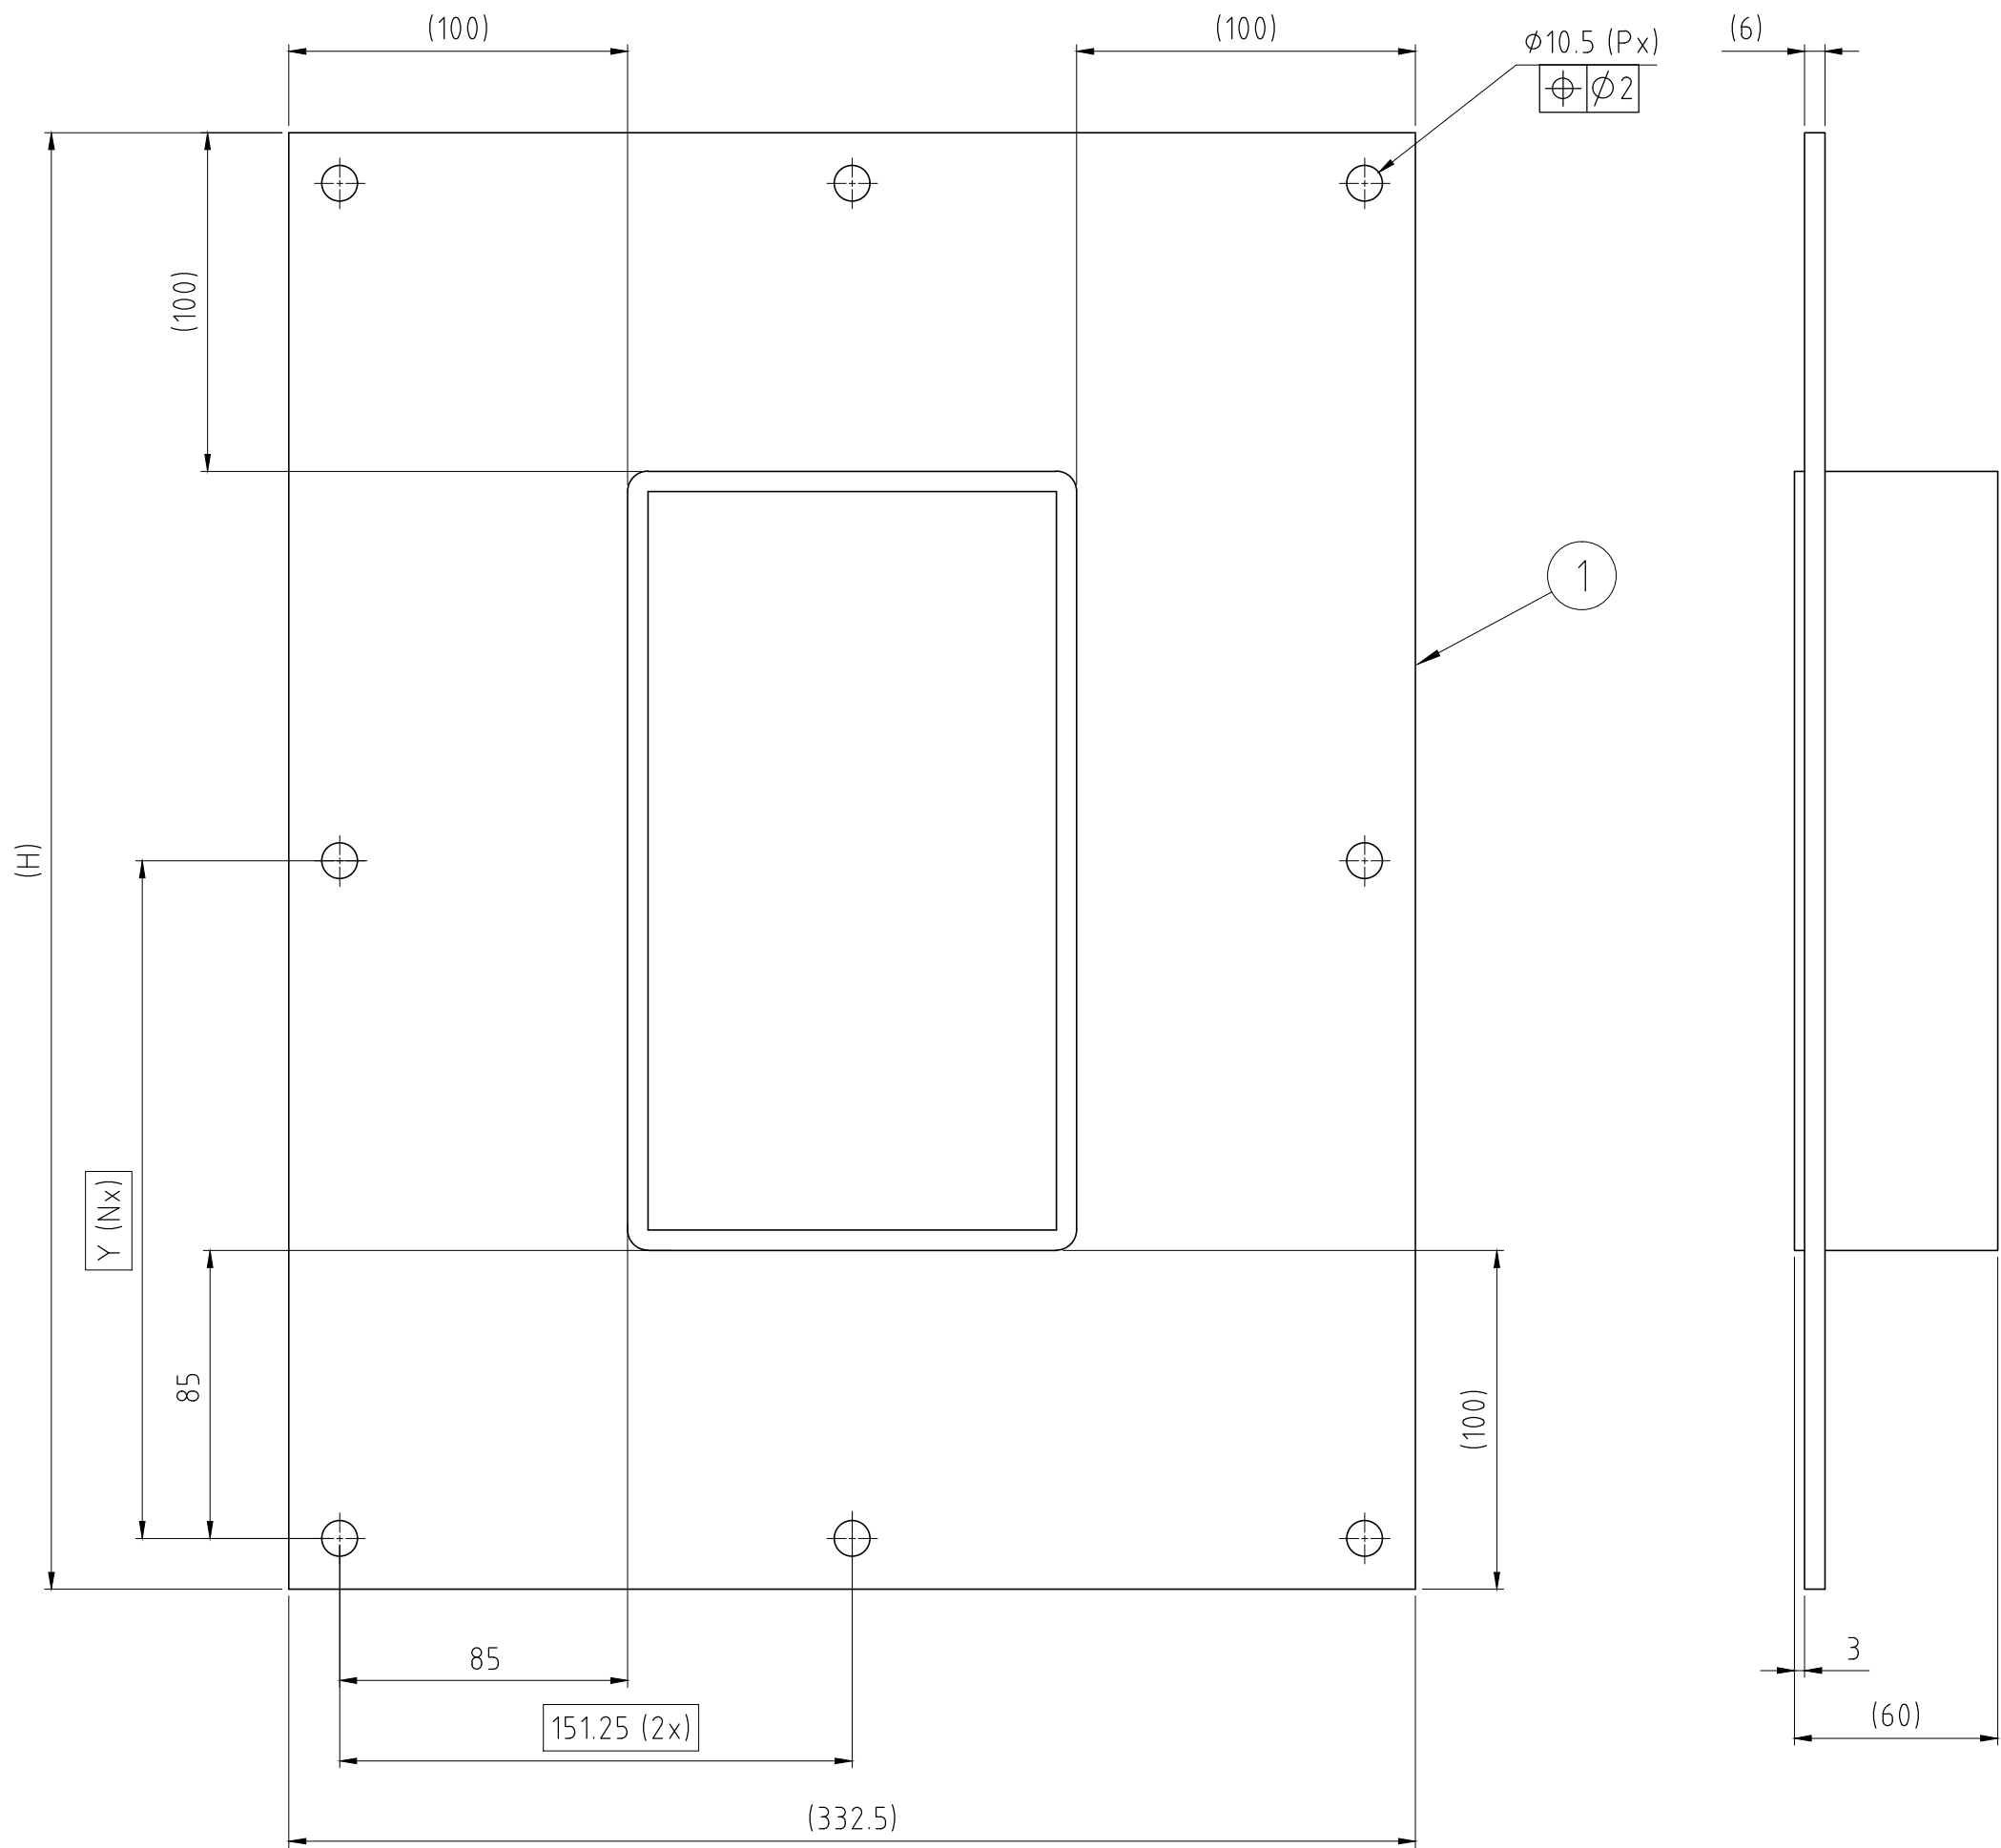

TYPE	H (mm)	Y (mm)	N	P
GH 2x1 FL100	313	141,5	2	8
GH 4x1 FL100	371,5	170,8	2	8
GH 6x1 FL100	430	133,3	3	10
GH 8x1 FL100	490	153,3	3	10

D	UPDATED TITLE BORDER	2019-05-03	se-linado
Rev	Type of revision	Date	Sign

1	1	G FRAME FL100 SINGLE	S1025609	
Item	Qty	Designation	Specification	NetWeight
General tolerances used for manufacturing shown in document DDC-00280		Designed by se-fontor	Created Date 2011-11-17	Latest save date 2019-05-07
		Format A2	Scale 1:2	Sheet no
		Title GH FRAME FL100 SINGLE FRAME		Projection method
		Restricted due to Information drawing		Rev D
		Drawing number S1025599		