


D	UPDATED TITLE BORDER	2019-05-03	se-linado
Rev	Type of revision	Date	Sign

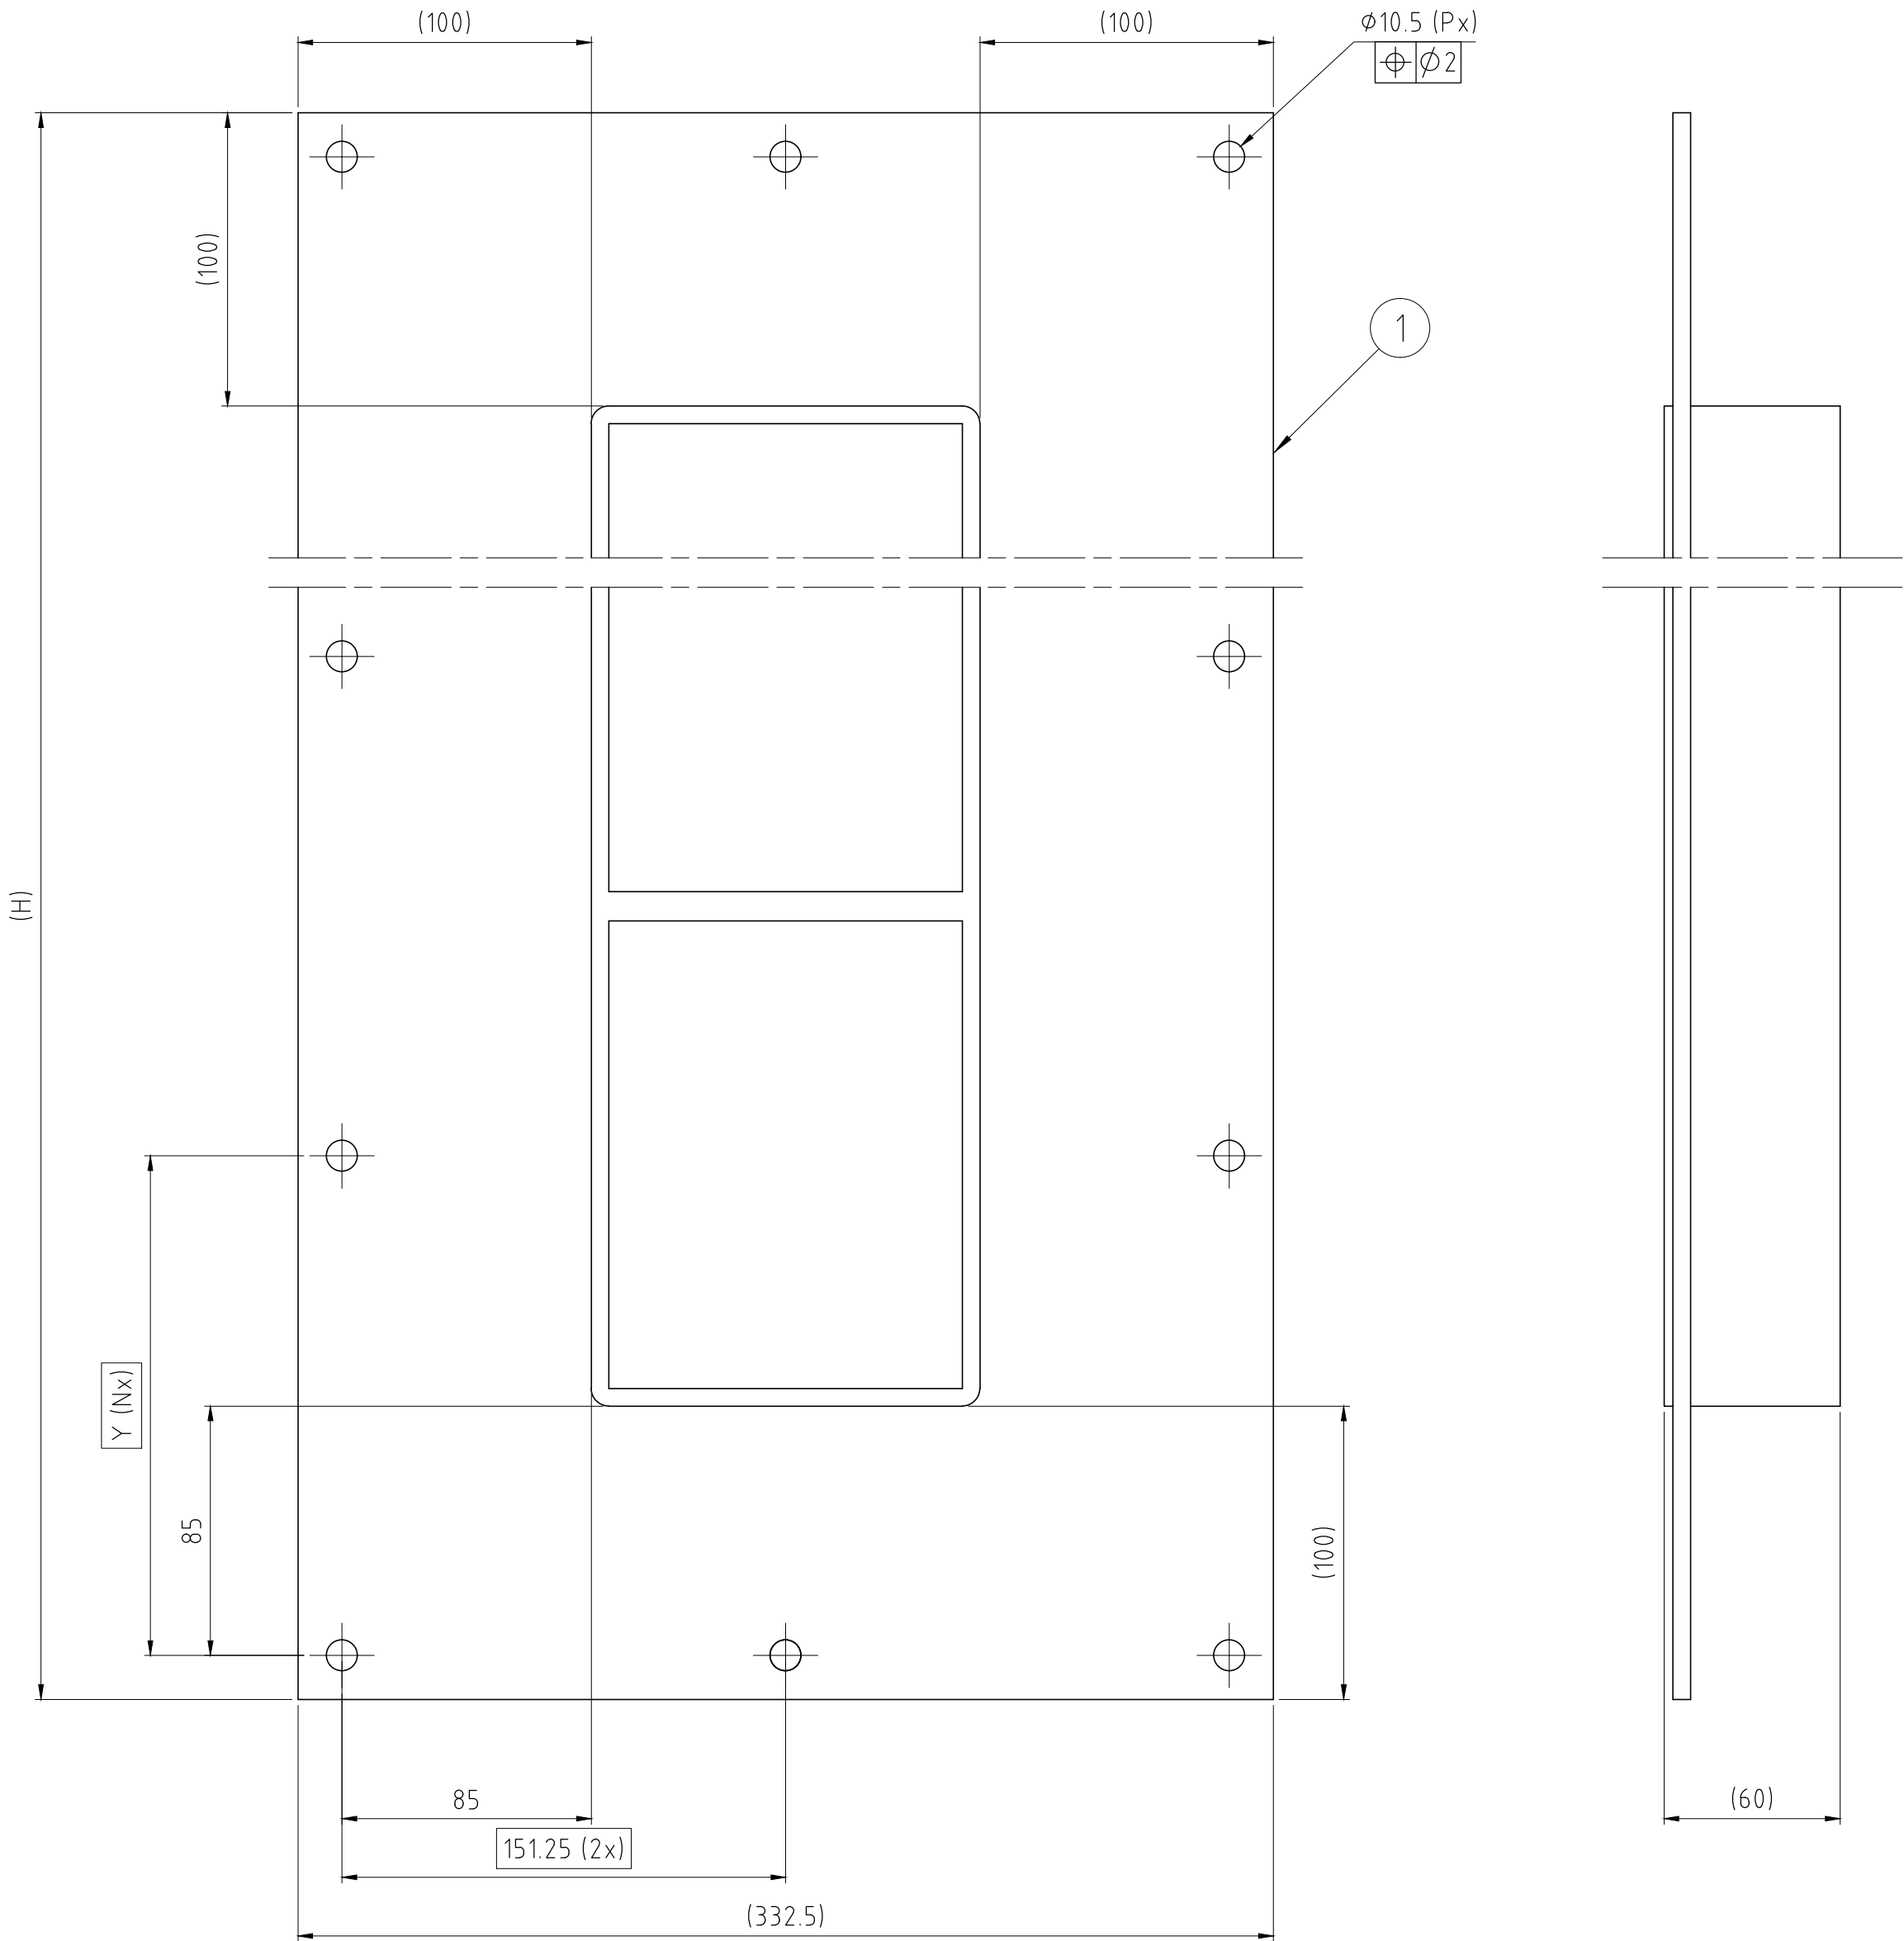

TYPE	H (mm)	Y (mm)	N	P
GH 2+2x1 FL100	424	131,3	3	10
GH 4+4x1 FL100	541	170,3	3	10
GH 6+6x1 FL100	658	157,0	4	12
GH 8+8x1 FL100	778	149,6	5	14
GH 2+2+2x1 FL100	535	168,3	3	10
GH 4+4+4x1 FL100	710,5	170,1	4	12
GH 6+6+6x1 FL100	886	171,2	5	14
GH 8+8+8x1 FL100	1066	172,7	6	16
GH 2+2+2+2x1 FL100	646	154,0	4	12
GH 4+4+4+4x1 FL100	880	170,0	5	14
GH 6+6+6+6x1 FL100	1114	154,9	7	18
GH 8+8+8+8x1 FL100	1354	165,5	8	20

1	1	G FRAME FL100 +SINGLE	S1025610				
Item	Qty	Designation	Specification				NetWeight
General tolerances used for manufacturing shown in document DDC-00290		Designed by se-ronor	Created Date 2011-11-17	Latest save date 2019-05-07	Format A2	Scale 1:2	Sheet no
		Title GH FRAME FL100 +SINGLE FRAME				Projection method 	
		Restricted due to Information drawing				Drawing number S1025600	Rev D