


B	UPDATED TITLE BORDER	2019-05-03	se-linado
Rev	Type of revision	Date	Sign

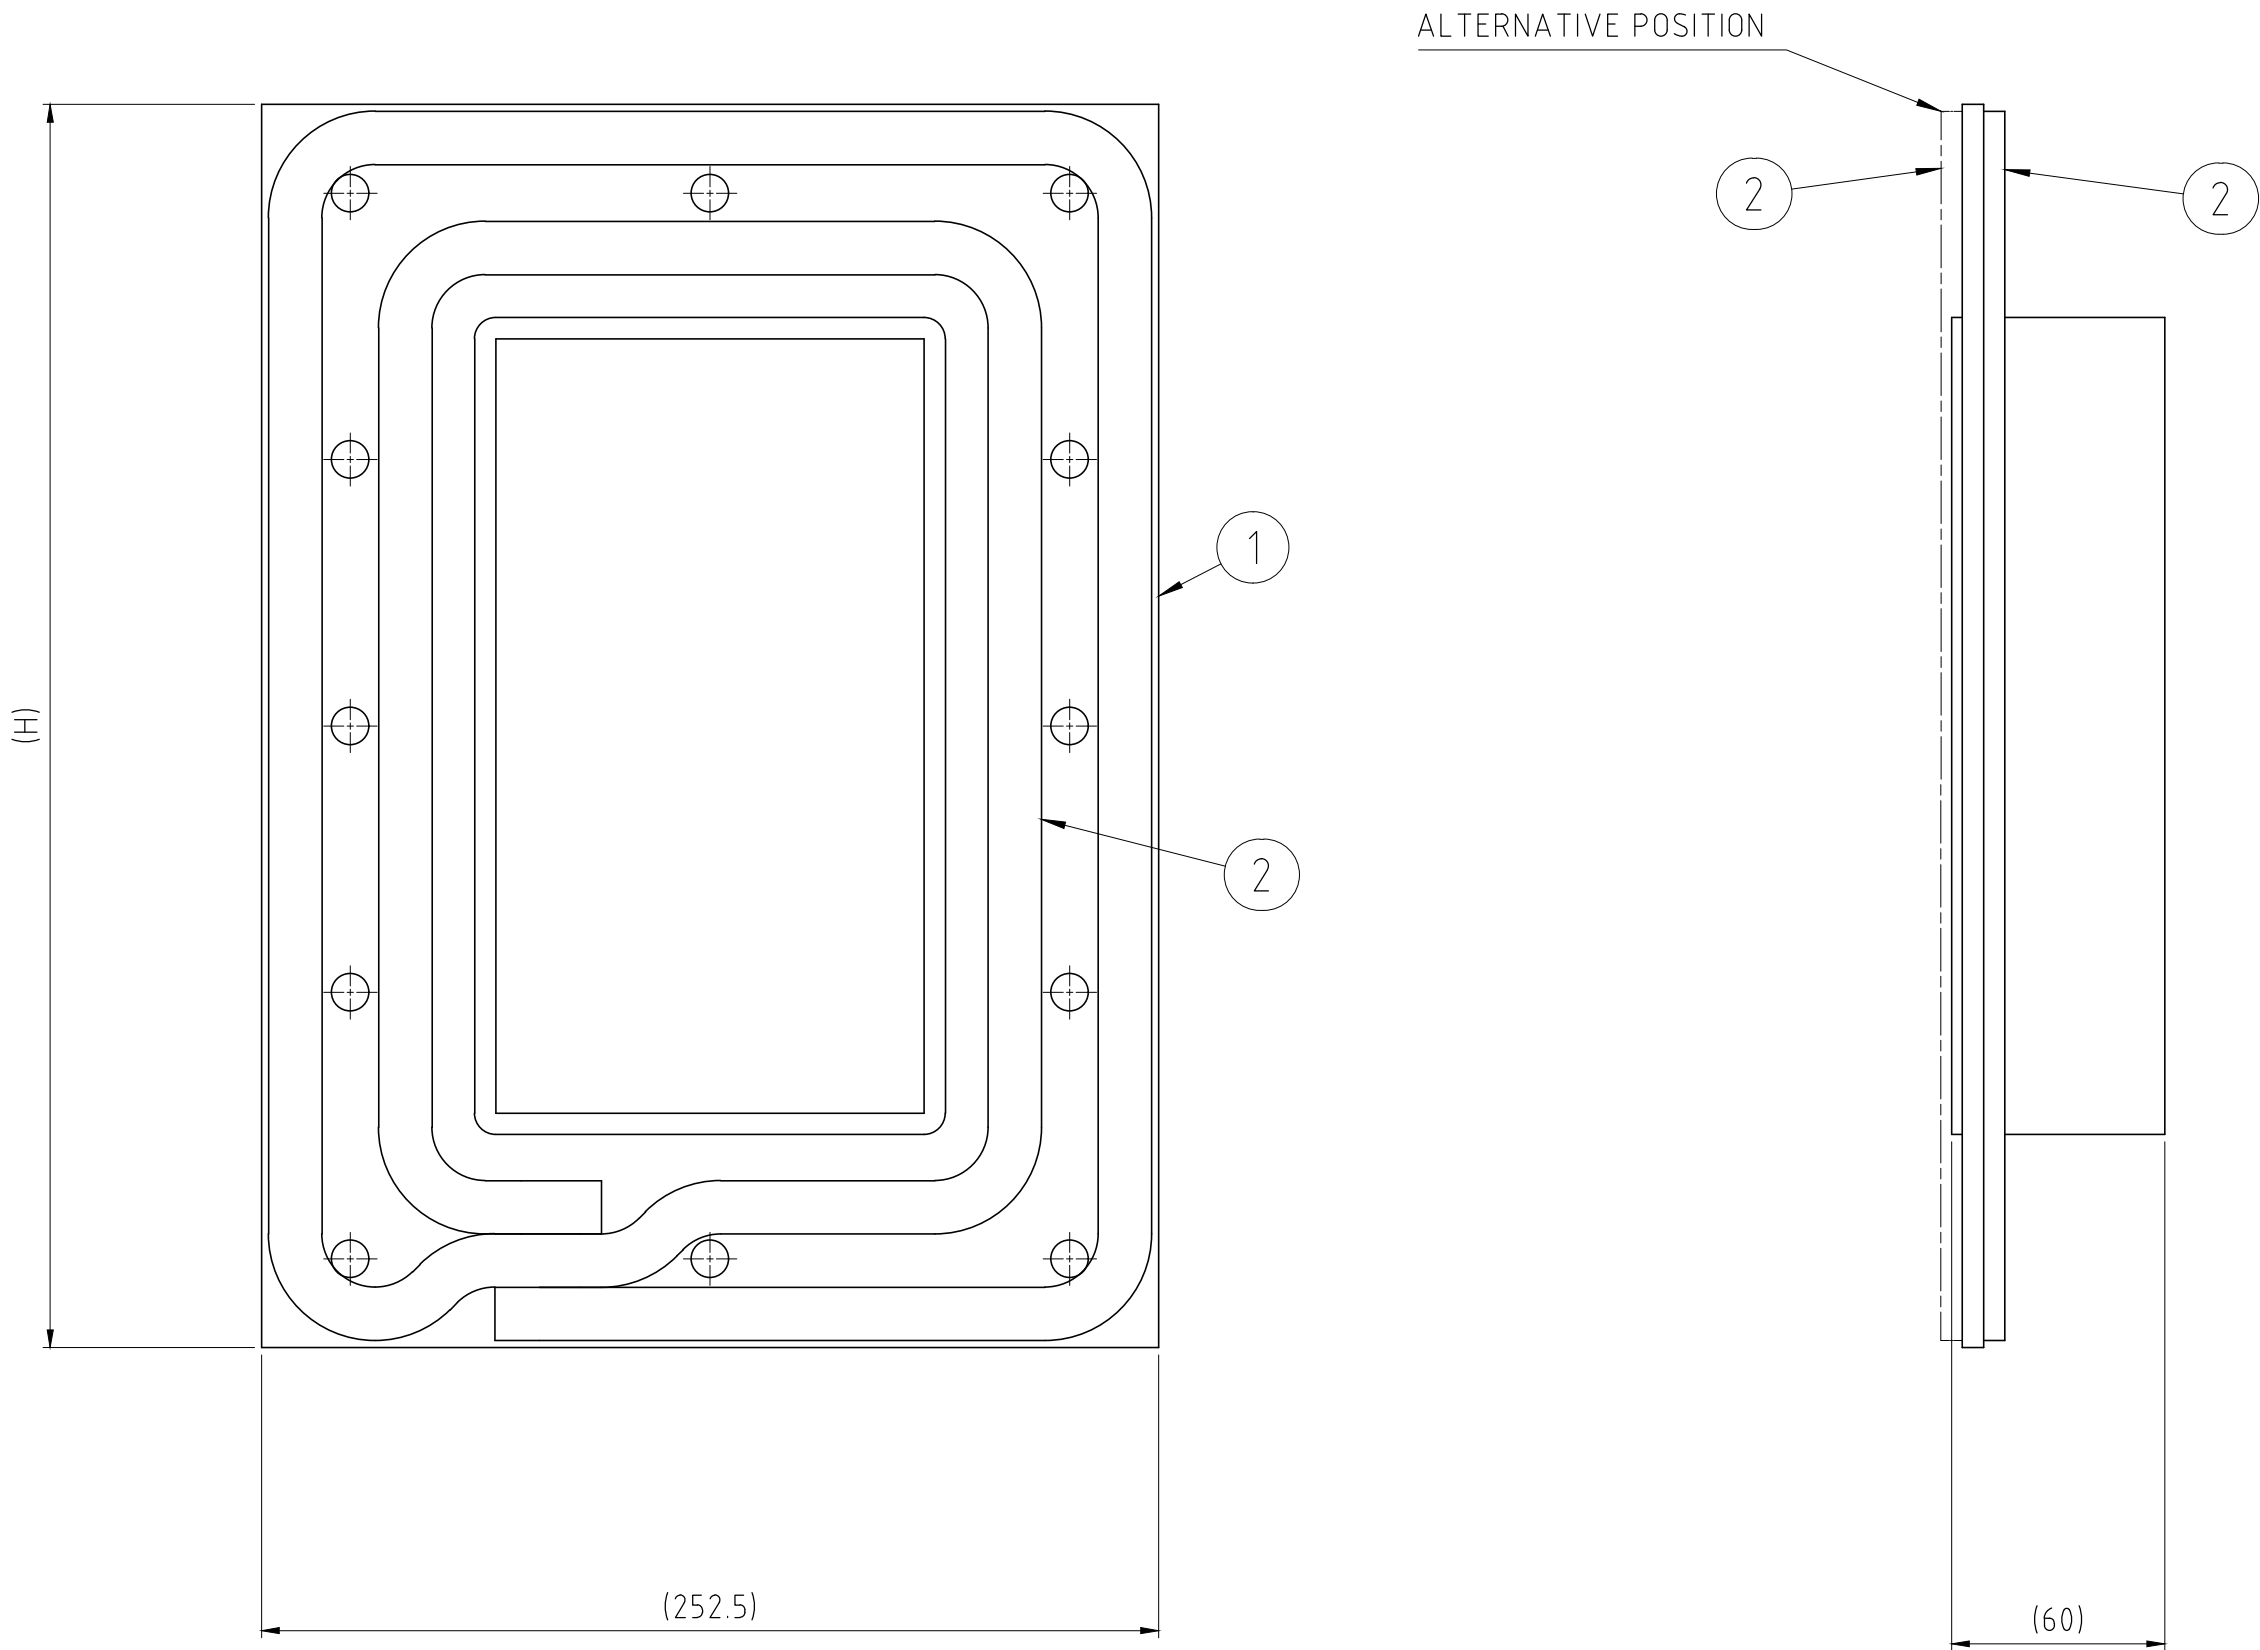

TYPE	H
GHM 2x1	233
GHM 4x1	291.5
GHM 6x1	350
GHM 8x1	410

3	1	INSTALLATION INSTR.							
2	1	TSL. 15x6	S1037413						
1	1	SINGLE FRAME	S1010385						
Item	Qty	Designation	Specification						NetWeight
General tolerances used for manufacturing shown in document DDC-00280			Designed by se-luckri	Created Date 2013-12-09	Latest save date 2019-05-07	Format A2	Scale 1:2	Sheet no	TotWeight -
 www.roxtec.com			Title GHM FRAME INCL. TSL. 15x6 SINGLE FRAME						Projection method 
			Restricted due to Information drawing						Rev B
			Drawing number S1036699						