


B	UPDATED TITLE BORDER	2019-05-03	se-linado
Rev	Type of revision	Date	Sign

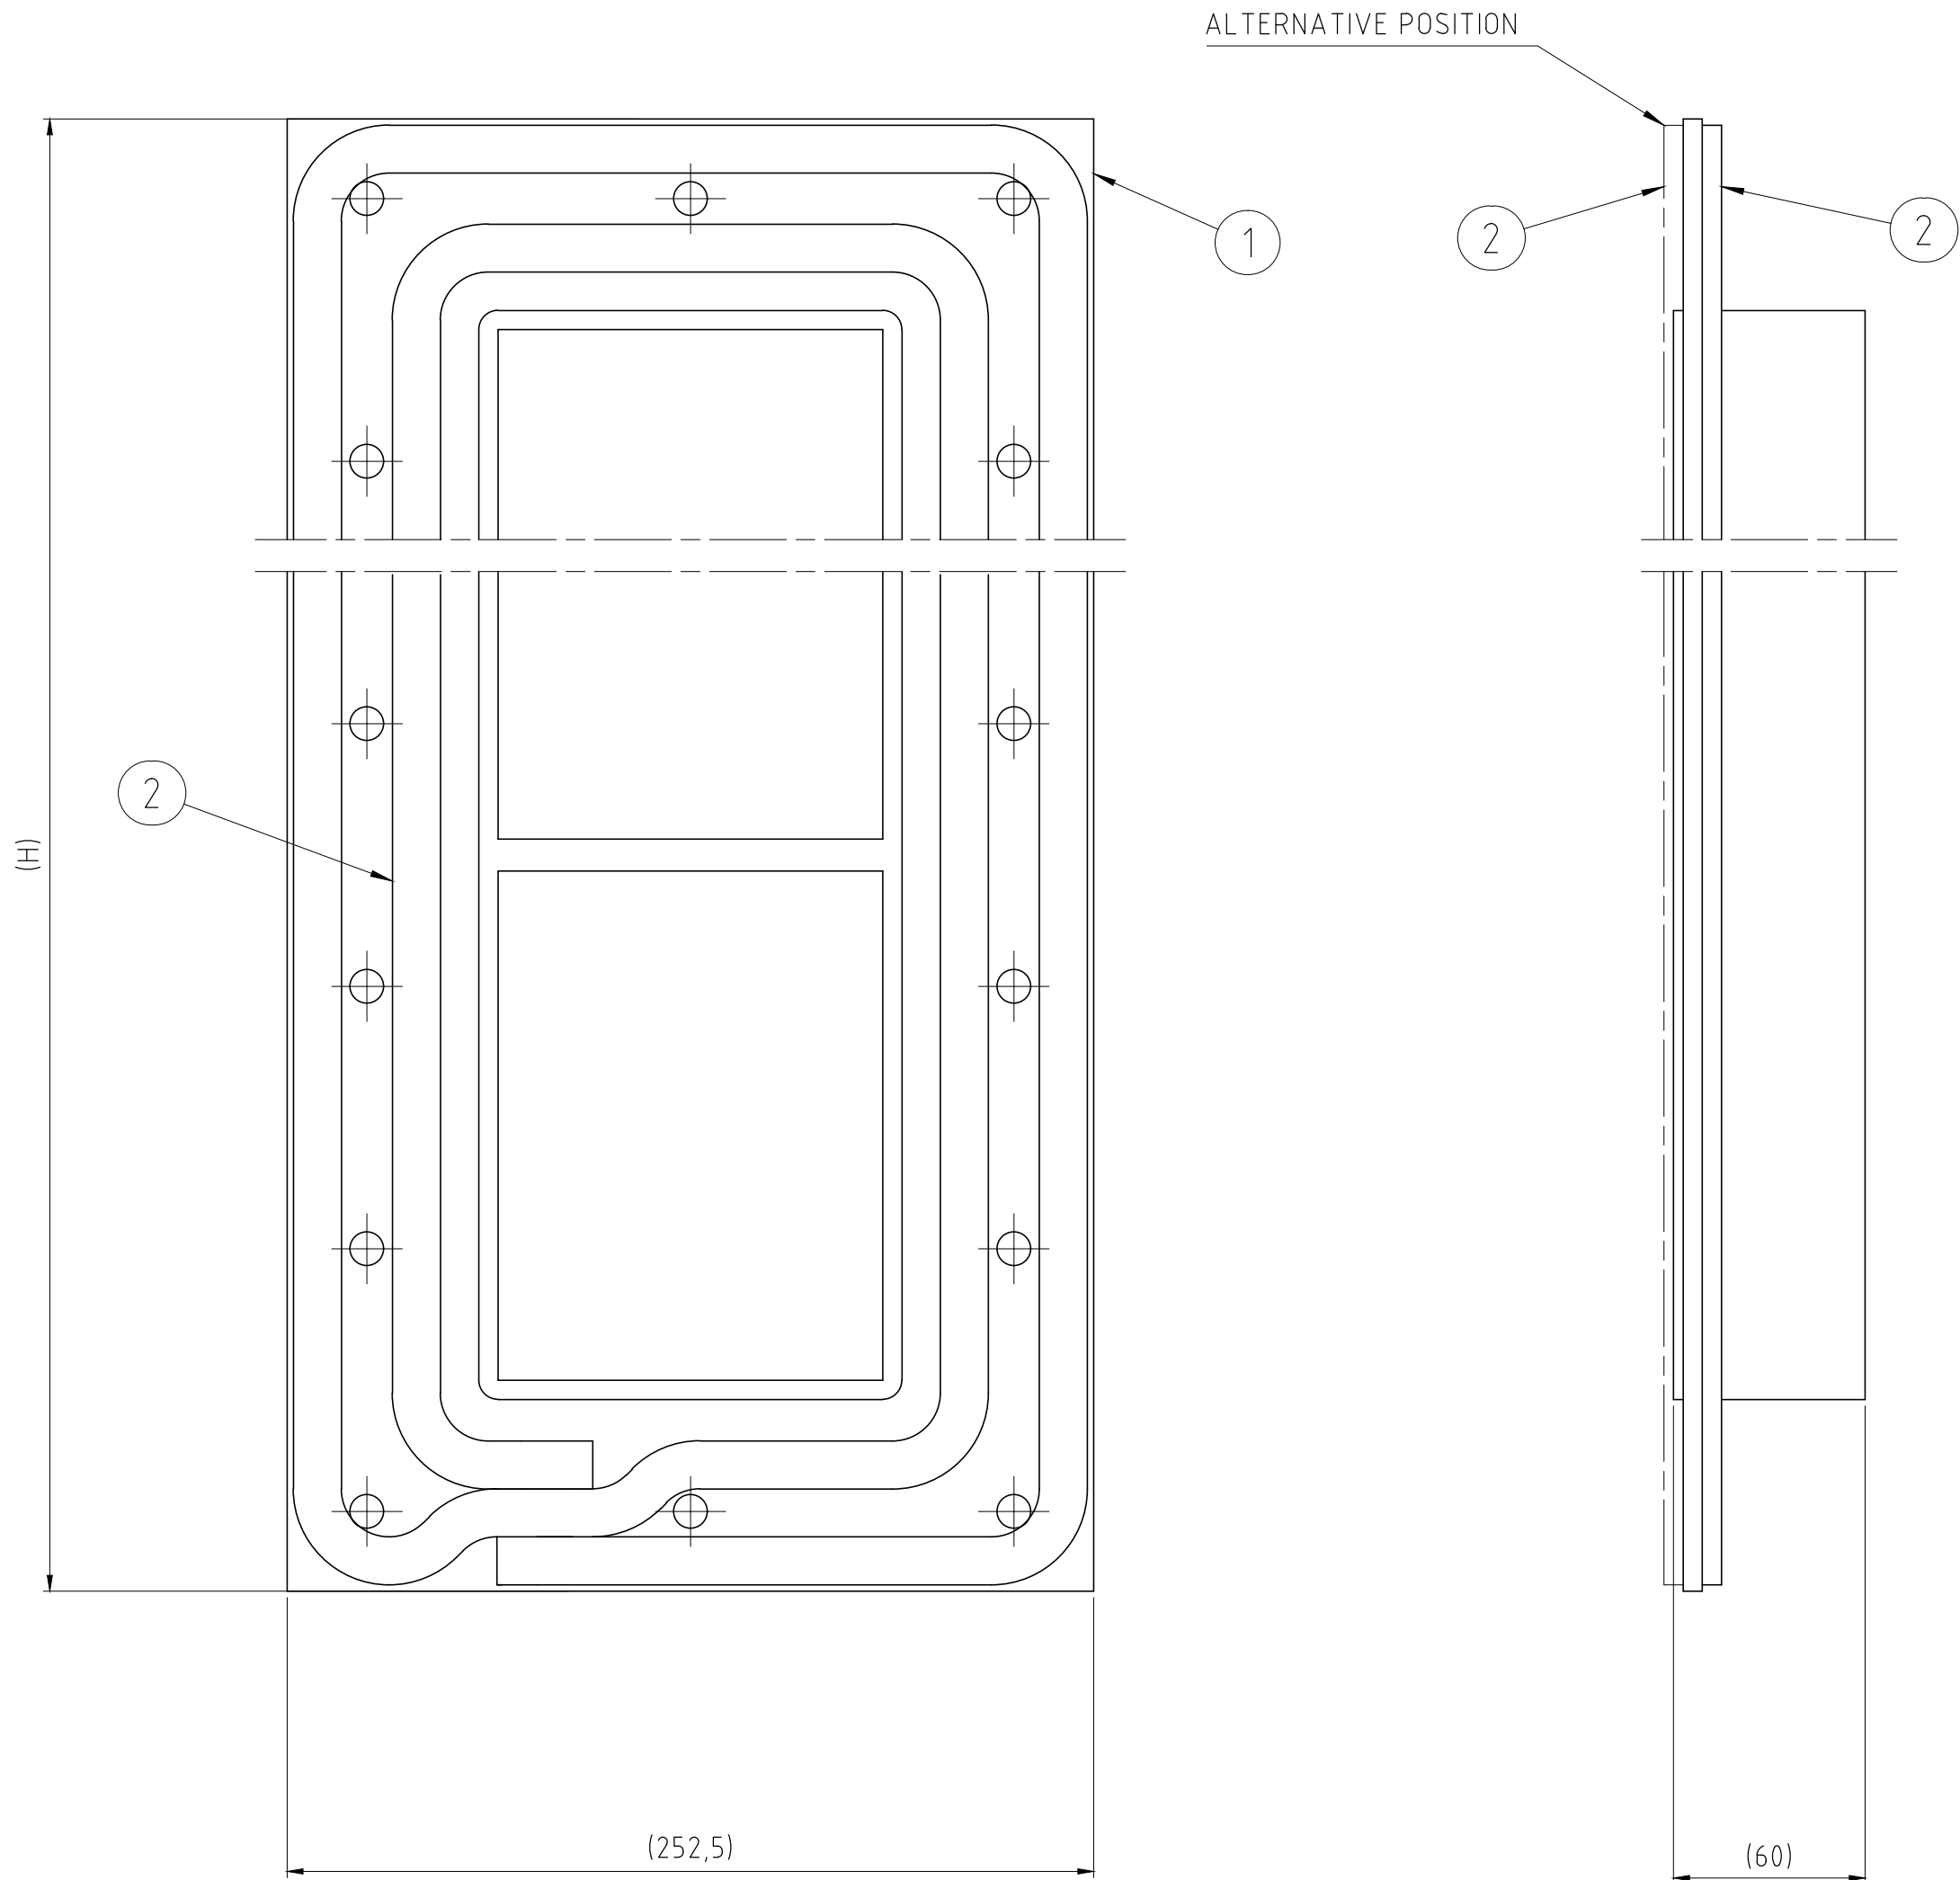

TYPE	H
GHM 2+2x1	344
GHM 4+4x1	461
GHM 6+6x1	578
GHM 8+8x1	698

TYPE	H
GHM 2+2+2x1	455
GHM 4+4+4x1	630.5
GHM 6+6+6x1	806
GHM 8+8+8x1	986

TYPE	H
GHM 2+2+2+2x1	566
GHM 4+4+4+4x1	800
GHM 6+6+6+6x1	1034
GHM 8+8+8+8x1	1274

3	1	INSTALLATION INSTR.							
2	1	TSL. 15x6	S1037413						
1	1	+ SINGLE FRAME	S1010387						
Item	Qty	Designation	Specification						NetWeight
General tolerances used for manufacturing shown in document DDC-00280			Designed by se-luckri	Created Date 2013-12-12	Latest save date 2019-05-07	Format A2	Scale 1:2	Sheet no	TotWeight -
 Roxtec www.roxtec.com			Title GHM FRAME INCL. TSL. 15x6 + SINGLE FRAME Restricted due to						Projection method 
			Information drawing				Drawing number S1036758		Rev B