



C	BALLOONS AND BOM ADDED	2021-03-16	se-henols
Rev	Type of revision	Date	Sign

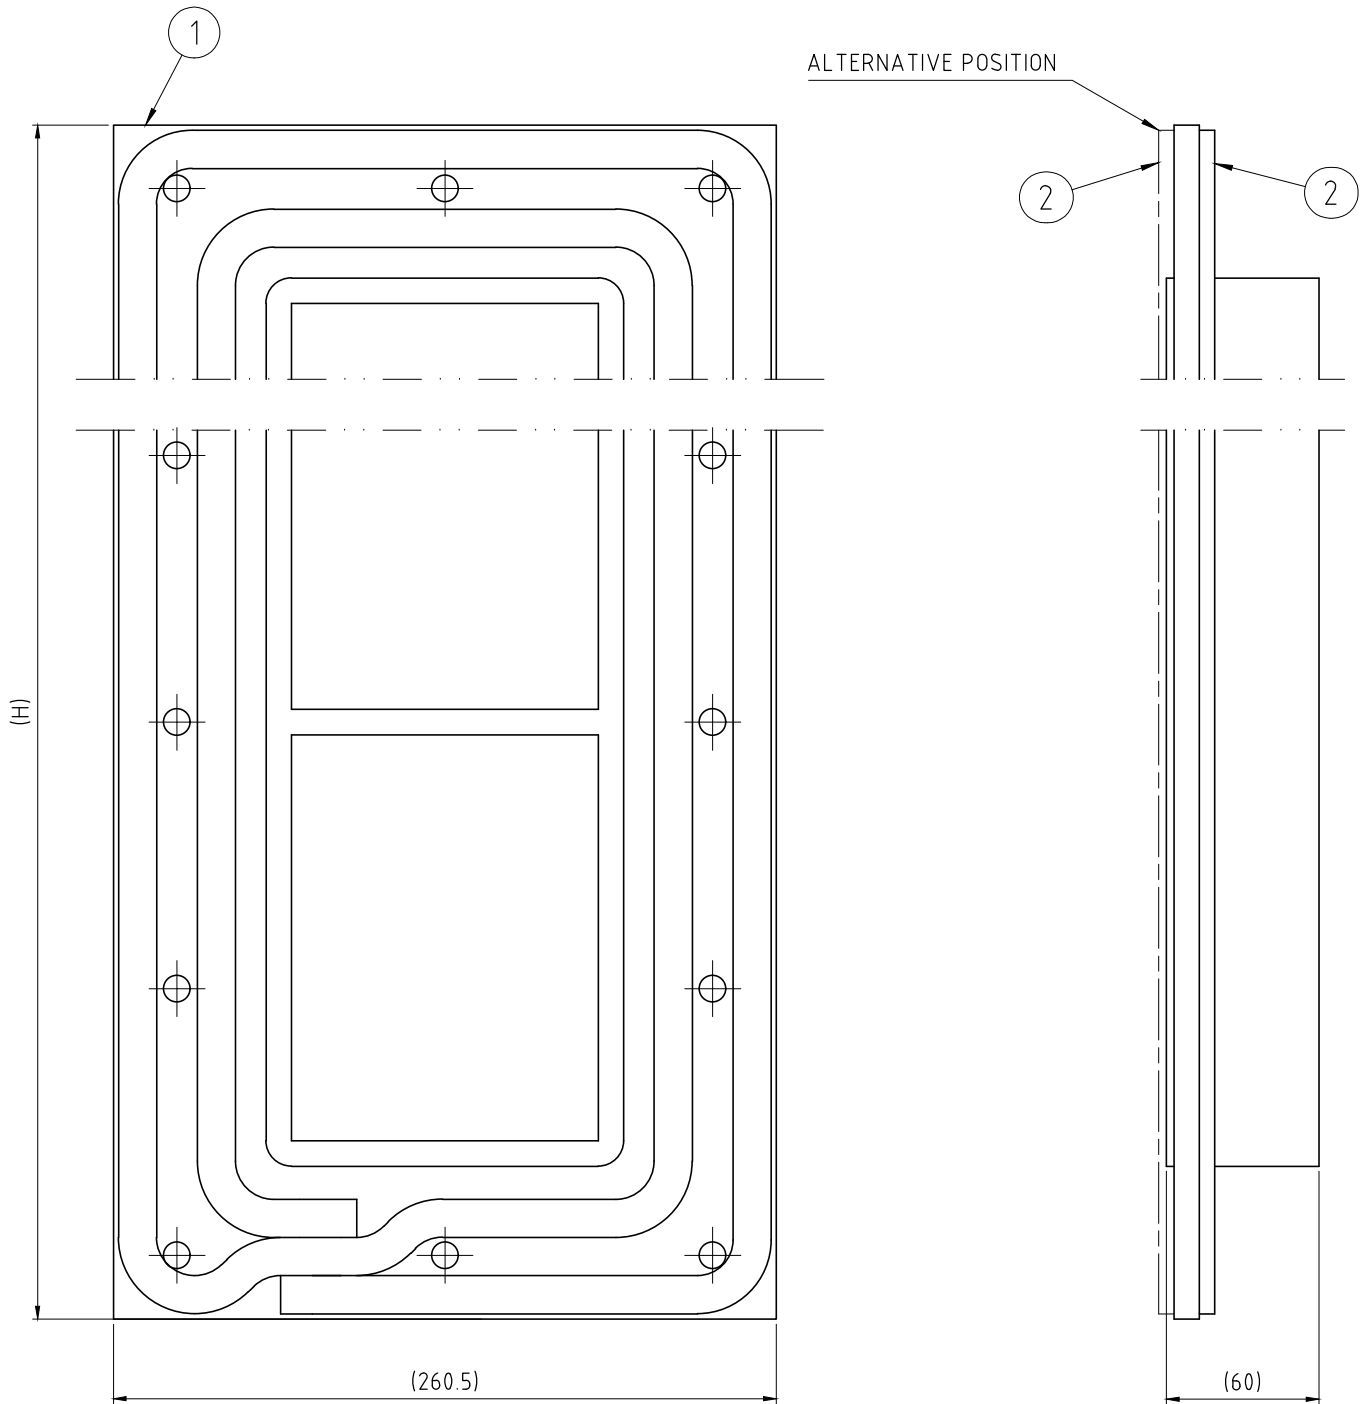

TYPE	H
SFHM 2+2x1	352
SFHM 4+4x1	469
SFHM 6+6x1	586
SFHM 8+8x1	706
SFHM 2+2+2x1	463
SFHM 4+4+4x1	638,5
SFHM 6+6+6x1	814
SFHM 8+8+8x1	994
SFHM 2+2+2+2x1	574
SFHM 4+4+4+4x1	808
SFHM 6+6+6+6x1	1042
SFHM 8+8+8+8x1	1282

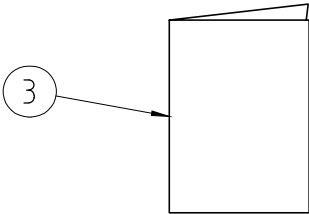

3	1	INSTALLATION INSTR.						
2	1	TSL. 15x6	S1037413					
1	1	+ SINGLE FRAME	S1010392					
Item	Qty	Designation	Specification					Net Weight
General tolerances used for manufacturing shown in document DDC-002180		Designed by se-luckri	Created Date 2014-01-30	Latest save date 2021-03-16	Format A2	Scale 1:2	Sheet no	Tot Weight —
		Title SFHM FRAME INCL. TSL 15x6 + SINGLE FRAME						Projection method 
www.roxtec.com		Restricted due to Information drawing		Drawing number S1037340		Rev C		