


B	UPDATED TITLE BORDER	2019-05-03	se-linado
Rev	Type of revision	Date	Sign

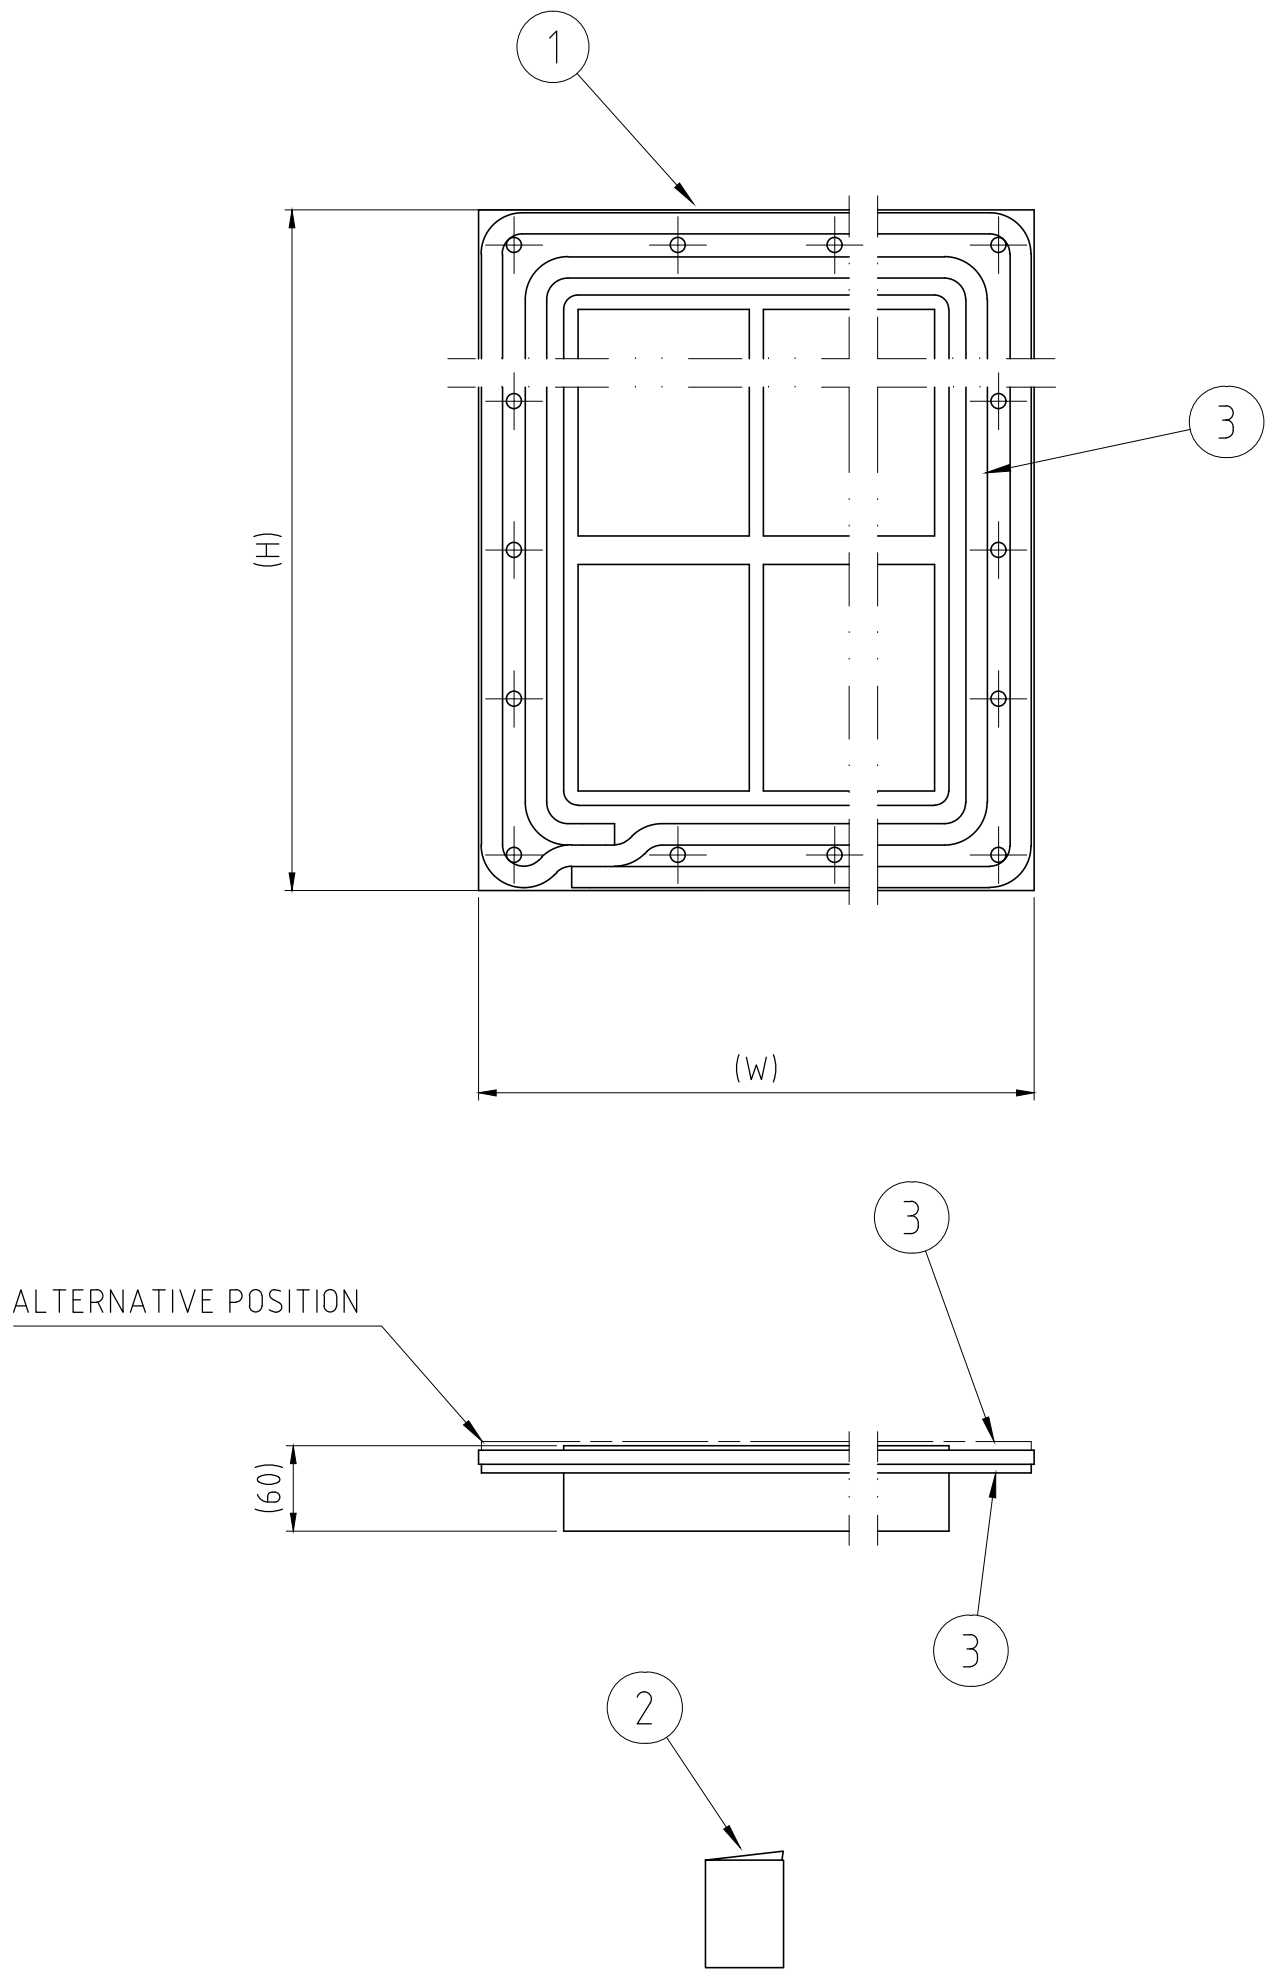

TYPE	H	W
SFHM 2+2x2	362	391
SFHM 4+4x2	479	391
SFHM 6+6x2	596	391
SFHM 8+8x2	716	391
SFHM 2+2x3	362	521,5
SFHM 4+4x3	479	521,5
SFHM 6+6x3	596	521,5
SFHM 8+8x3	716	521,5
SFHM 2+2x4	362	652
SFHM 4+4x4	479	652
SFHM 6+6x4	596	652
SFHM 8+8x4	716	652
SFHM 2+2x5	362	782,5
SFHM 4+4x5	479	782,5
SFHM 6+6x5	596	782,5
SFHM 8+8x5	716	782,5
SFHM 2+2x6	362	913
SFHM 4+4x6	479	913
SFHM 6+6x6	596	913
SFHM 8+8x6	716	913
SFHM 2+2x7	362	1043,5
SFHM 4+4x7	479	1043,5
SFHM 6+6x7	596	1043,5
SFHM 8+8x7	716	1043,5
SFHM 2+2x8	362	1174
SFHM 4+4x8	479	1174
SFHM 6+6x8	596	1174
SFHM 8+8x8	716	1174
SFHM 2+2x9	362	1304,5
SFHM 4+4x9	479	1304,5
SFHM 6+6x9	596	1304,5
SFHM 8+8x9	716	1304,5
SFHM 2+2x10	362	1435
SFHM 4+4x10	479	1435
SFHM 6+6x10	596	1435
SFHM 8+8x10	716	1435

TYPE	H	W
SFHM 2+2+2x2	483	391
SFHM 4+4+4x2	658,5	391
SFHM 6+6+6x2	834	391
SFHM 8+8+8x2	1014	391
SFHM 2+2+2x3	483	521,5
SFHM 4+4+4x3	658,5	521,5
SFHM 6+6+6x3	834	521,5
SFHM 8+8+8x3	1014	521,5
SFHM 2+2+2x4	483	652
SFHM 4+4+4x4	658,5	652
SFHM 6+6+6x4	834	652
SFHM 8+8+8x4	1014	652
SFHM 2+2+2x5	483	782,5
SFHM 4+4+4x5	658,5	782,5
SFHM 6+6+6x5	834	782,5
SFHM 8+8+8x5	1014	782,5
SFHM 2+2+2x6	483	913
SFHM 4+4+4x6	658,5	913
SFHM 6+6+6x6	834	913
SFHM 8+8+8x6	1014	913
SFHM 2+2+2x7	483	1043,5
SFHM 4+4+4x7	658,5	1043,5
SFHM 6+6+6x7	834	1043,5
SFHM 8+8+8x7	1014	1043,5
SFHM 2+2+2x8	483	1174
SFHM 4+4+4x8	658,5	1174
SFHM 6+6+6x8	834	1174
SFHM 8+8+8x8	1014	1174
SFHM 2+2+2x9	483	1304,5
SFHM 4+4+4x9	658,5	1304,5
SFHM 6+6+6x9	834	1304,5
SFHM 8+8+8x9	1014	1304,5
SFHM 2+2+2x10	483	1435
SFHM 4+4+4x10	658,5	1435
SFHM 6+6+6x10	834	1435
SFHM 8+8+8x10	1014	1435

TYPE	H	W
SFHM 2+2+2+2x2	604	391
SFHM 4+4+4+4x2	838	391
SFHM 6+6+6+6x2	1072	391
SFHM 8+8+8+8x2	1312	391
SFHM 2+2+2+2x3	604	521,5
SFHM 4+4+4+4x3	838	521,5
SFHM 6+6+6+6x3	1072	521,5
SFHM 8+8+8+8x3	1312	521,5
SFHM 2+2+2+2x4	604	652
SFHM 4+4+4+4x4	838	652
SFHM 6+6+6+6x4	1072	652
SFHM 8+8+8+8x4	1312	652
SFHM 2+2+2+2x5	604	782,5
SFHM 4+4+4+4x5	838	782,5
SFHM 6+6+6+6x5	1072	782,5
SFHM 8+8+8+8x5	1312	782,5
SFHM 2+2+2+2x6	604	913
SFHM 4+4+4+4x6	838	913
SFHM 6+6+6+6x6	1072	913
SFHM 8+8+8+8x6	1312	913
SFHM 2+2+2+2x7	604	1043,5
SFHM 4+4+4+4x7	838	1043,5
SFHM 6+6+6+6x7	1072	1043,5
SFHM 8+8+8+8x7	1312	1043,5
SFHM 2+2+2+2x8	604	1174
SFHM 4+4+4+4x8	838	1174
SFHM 6+6+6+6x8	1072	1174
SFHM 8+8+8+8x8	1312	1174
SFHM 2+2+2+2x9	604	1304,5
SFHM 4+4+4+4x9	838	1304,5
SFHM 6+6+6+6x9	1072	1304,5
SFHM 8+8+8+8x9	1312	1304,5
SFHM 2+2+2+2x10	604	1435
SFHM 4+4+4+4x10	838	1435
SFHM 6+6+6+6x10	1072	1435
SFHM 8+8+8+8x10	1312	1435

3	1	TSL. 15X6	S1037413						
2	1	INSTALLATION INSTR.							
1	1	+ COMBINATION FRAME	S1010395						
Item	Qty	Designation	Specification						NetWeight
General tolerances used for manufacturing shown in document DDC-00280			Designed by	Created Date	Latest save date	Format	Scale	Sheet no	TotWeight
			se-luckri	2014-02-03	2019-05-07	A2	1:5		-
 Roxtec www.roxtec.com			Title						Projection method 
			SFHM FRAME INCL. TSL 15x6 + COMBINATION FRAME						
			Restricted due to			Drawing number		Rev	
			Information drawing			S1037367		B	