


C	UPDATED TITLE BORDER	2019-05-03	se-linado
Rev	Type of revision	Date	Sign

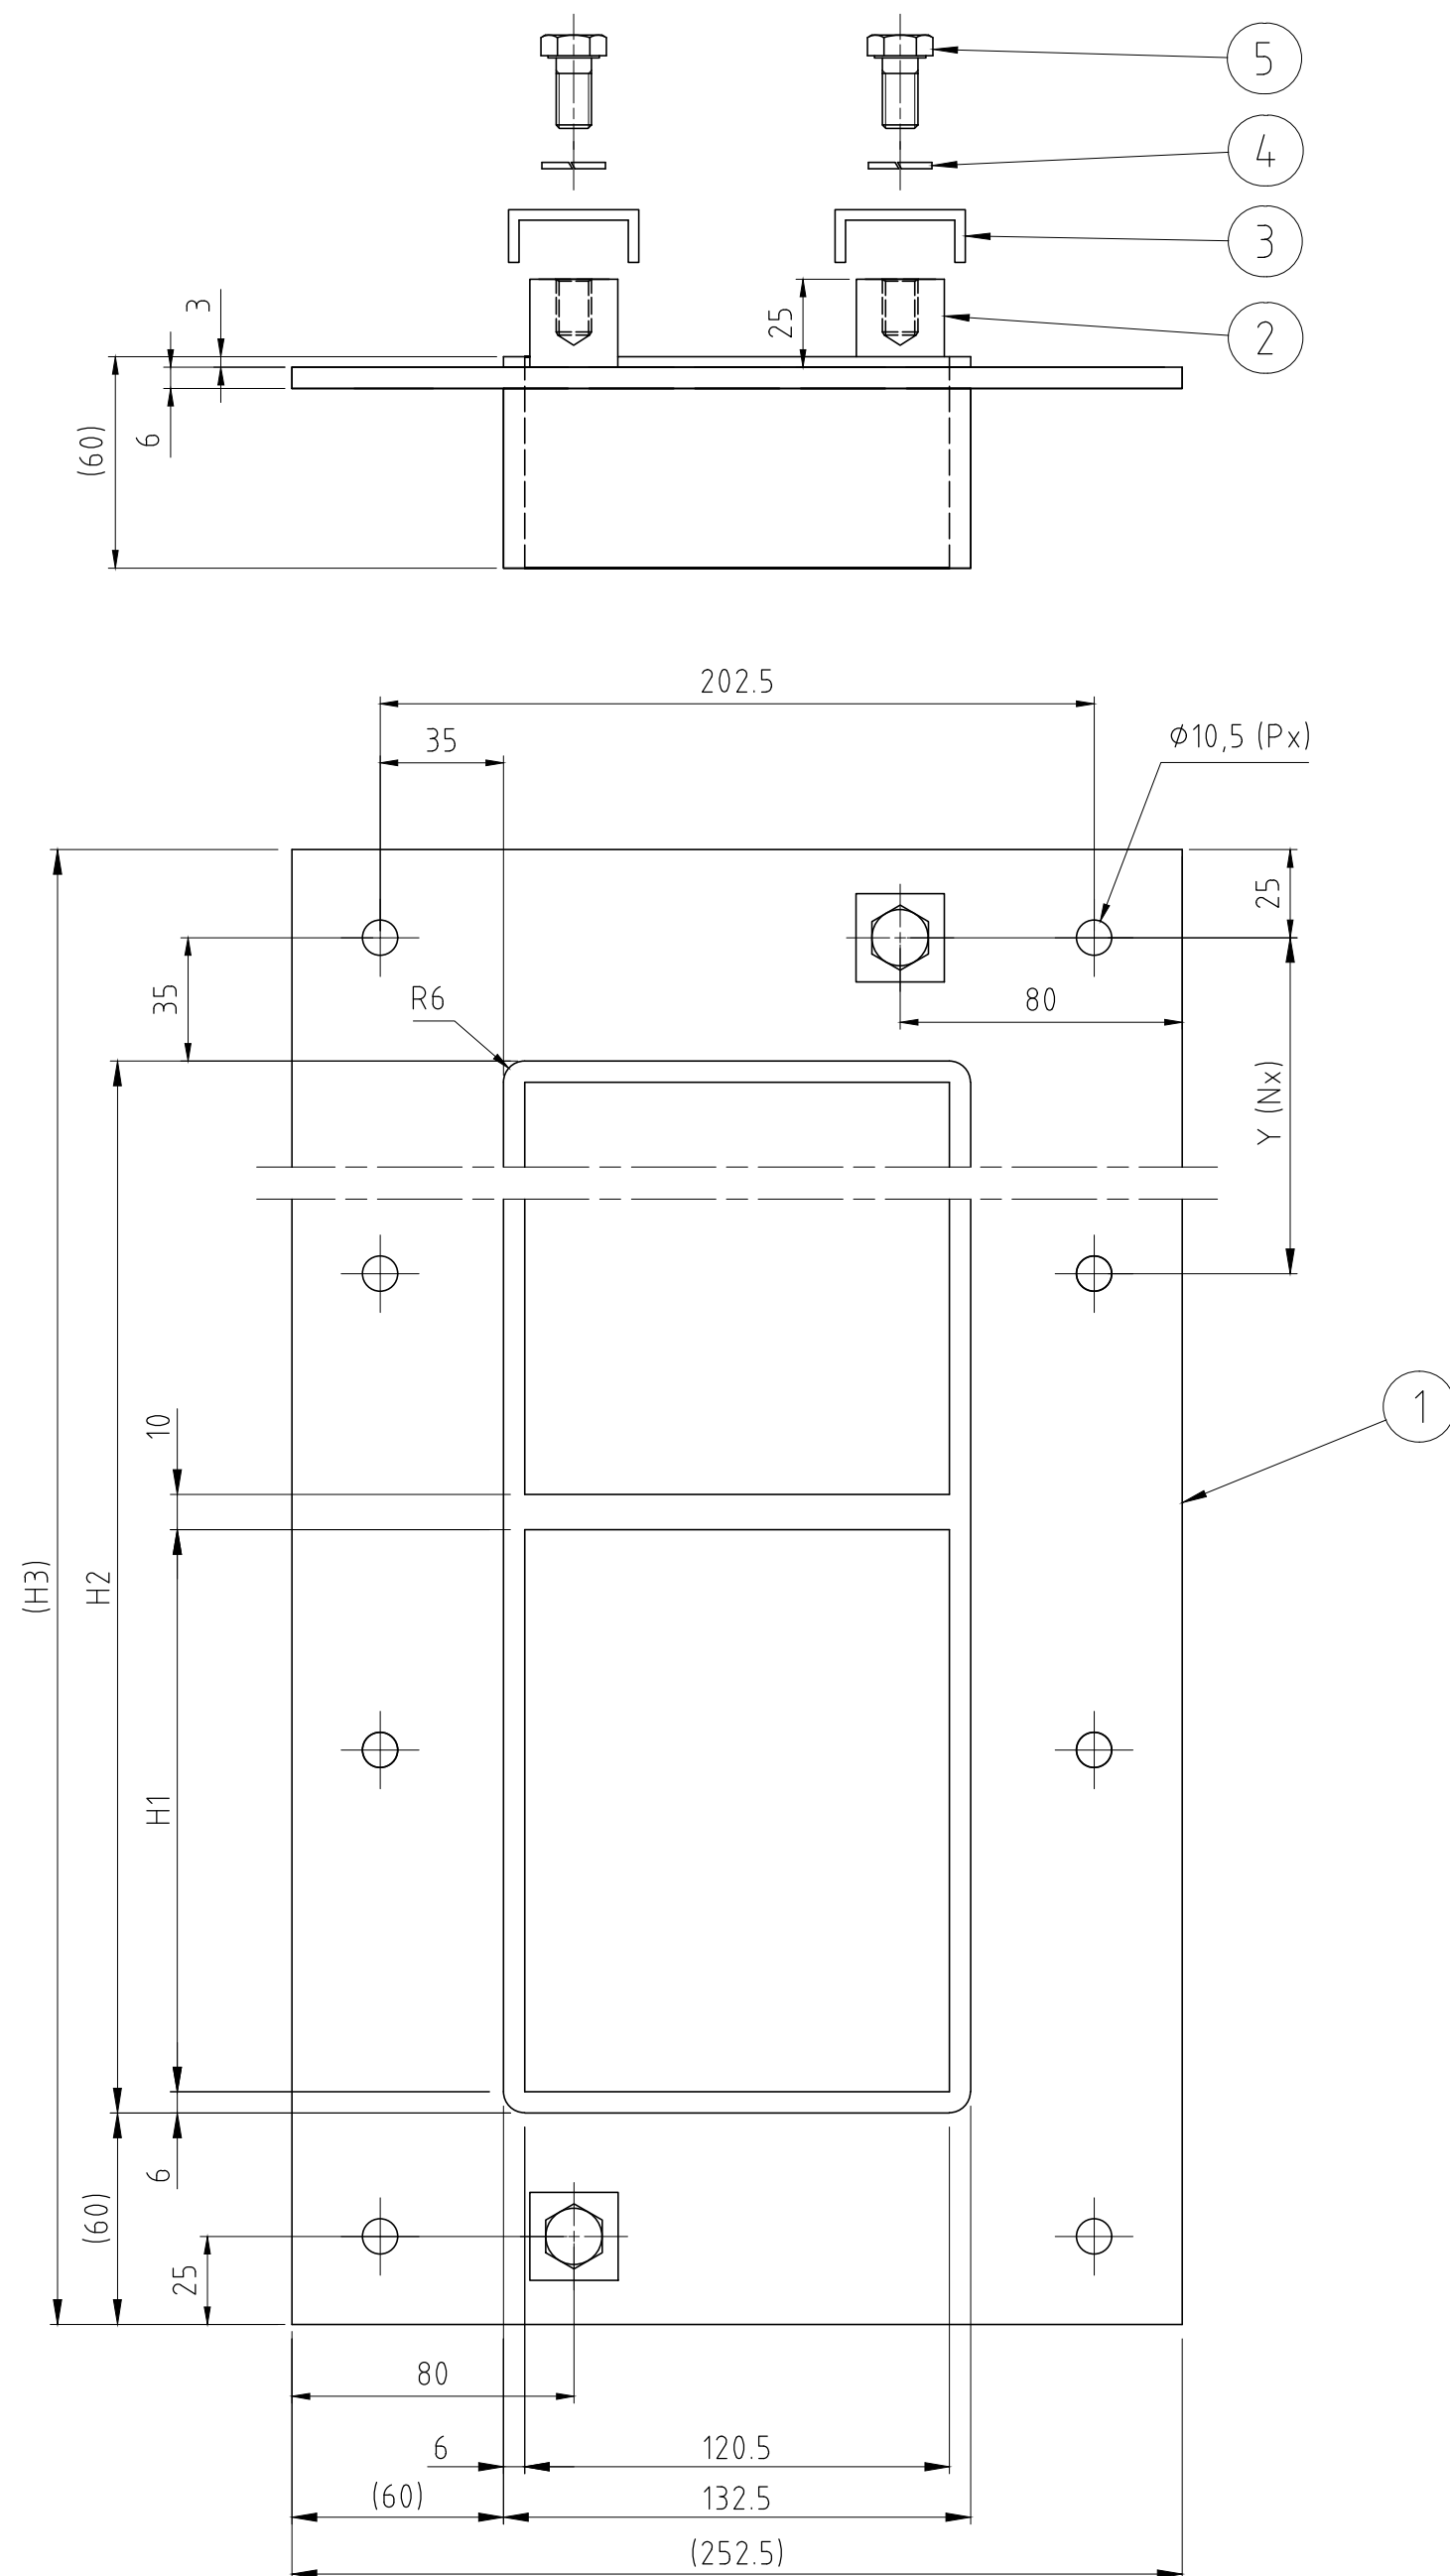

TYPE	H1	H2	H3	Y	N	P
GH BG 2+2x1	101	224	344	147	2	6
GH BG 4+4x1	159,5	341	461	137	3	8
GH BG 6+6x1	218	458	578	176	3	8
GH BG 8+8x1	278	578	698	162	4	10

TYPE	H1	H2	H3	Y	N	P
GH BG 2+2+2x1	101	335	455	135	3	8
GH BG 4+4+4x1	159,5	510,5	630,5	145,1	4	10
GH BG 6+6+6x1	218	686	806	151,2	5	12
GH BG 8+8+8x1	278	866	986	156	6	14

TYPE	H1	H2	H3	Y	N	P
GH BG 2+2+2+2x1	101	446	566	172	3	8
GH BG 4+4+4+4x1	159,5	680	800	150	5	12
GH BG 6+6+6+6x1	218	914	1034	164	6	14
GH BG 8+8+8+8x1	278	1154	1274	153	8	18

5	2	SCREW	M6S M10x20 GALV/A4						
4	2	RETAINER WASHER	M10 GALV/A4						
3	2	SADDLE WASHER							
2	2	EARTH STUD							
1	1	GH FRAME FL60+ SINGLE	S1039144						
Item	Qty	Designation	Specification						NetWeight
General tolerances used for manufacturing shown in document DDC-002189			Designed by t_c_service	Created Date 2014-05-12	Latest save date 2019-05-07	Format A2	Scale 1:2	Sheet no	TotWeight -
 Roxtec www.roxtec.com			Title GH FRAME BG + SINGLE FRAME		Projection method 				
			Restricted due to		Drawing number S1039144		Rev C		
			Information drawing						